


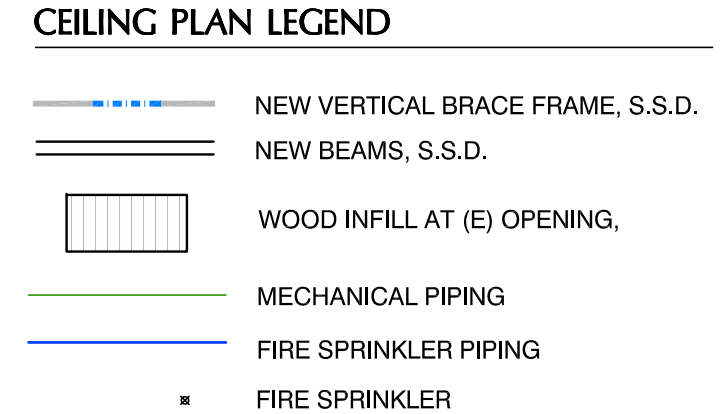

LIGHTING LEGEND


- F1 LED SUSPENDED CYLINDER DOWNLIGHT
F2 LED LINEAR GRAZE
F3 LED TAPE LIGHT
F4 LED PAR W/ INTERCHANGEABLE LENSES
F5 LED PENDANT DOWNLIGHT
F6 LED LINEAR WALL WASH
F7 LED SUSPENDED LINEAR DIRECT/INDIRECT
F7A LED SUSPENDED LINEAR DIRECT/INDIRECT
F8 LED SURFACE MOUNTED TAPE LIGHT
F9 LED RECTANGULAR RED LIGHT WASH FIXTURE
F10 NOT USED
F11 LINEAR WALL MOUNTED DOWNLIGHT
F12 SURFACE MOUNTED WALL WASH DOWNLIGHT
F13 LED DOWNLIGHT PENDANT
F14 FLOOR LAMP (BY TENANT, FF & E)- SEE FLOOR PLANS
F15 PENDANT
F16 LED LINEAR TABLE LIGHT AT DESKS- COORDINATE WITH FURNITURE VENDOR
F17 LED DOWNLIGHT PENDANT
F18 RECTANGULAR VANITY LIGHT
F19 SURFACE MOUNTED LINEAR LED TAPE LIGHT
F20 SURFACE MOUNTED LED STRIP LIGHT
F21 DESK LAMP
F22 BACKLIT 'JUUL' SIGNAGE BY SIGNAGE CONTRACTOR
F23 WALL MOUNTED SIGN LIGHTS
F24 LED SUSPENDED CYLINDER DOWNLIGHT
F25 LED FLEXIBLE STRIP LIGHT- SEE FLOOR PLANS
EXISTING FIXTURES, REFURBISH AND INSTALL (N) LED LAMPS
• EF1 AT MAIN LEVEL WALL FIXTURES
• EF2 AT SUSPENDED MEZZANINE LEVEL FIXTURES
- EXTERIOR:
FX1 WALL MOUNTED LED DIRECT LIGHT
FX2 WALL MOUNTED LED
FX3 LED FLEXIBLE STRIP- SEE FLOOR PLANS
FX4 NOT USED
FX5 HANDRAIL WITH INTEGRATED LED LIGHTING- SEE 1/A2.1
FX6 LED BOLLARD- SEE 1/A2.1

NOTES

- ELECTRICAL ENGINEER TO PROVIDE CIRCUITING, EMERGENCY EGRESS LIGHTING DESIGN AND TITLE 24 COMPLIANCE DOCUMENTATION
- SEE SECTIONS AND INTERIOR ELEVATIONS FOR MOUNTING HEIGHTS. CONSULT ARCHITECT WHERE NOT SHOWN
- SEE FLOOR PLANS FOR F14 FLOOR LAMP AND LIGHTING AT DECK, STAIRS AND LANDSCAPING
- EMERGENCY LIGHTING AND TITLE 24 BY ELECTRICAL ENGINEER

CEILING PLAN LEGEND

- NEW VERTICAL BRACE FRAME, S.S.D.
NEW BEAMS, S.S.D.
WOOD INFILL AT (E) OPENING,
MECHANICAL PIPING
FIRE SPRINKLER PIPING
FIRE SPRINKLER

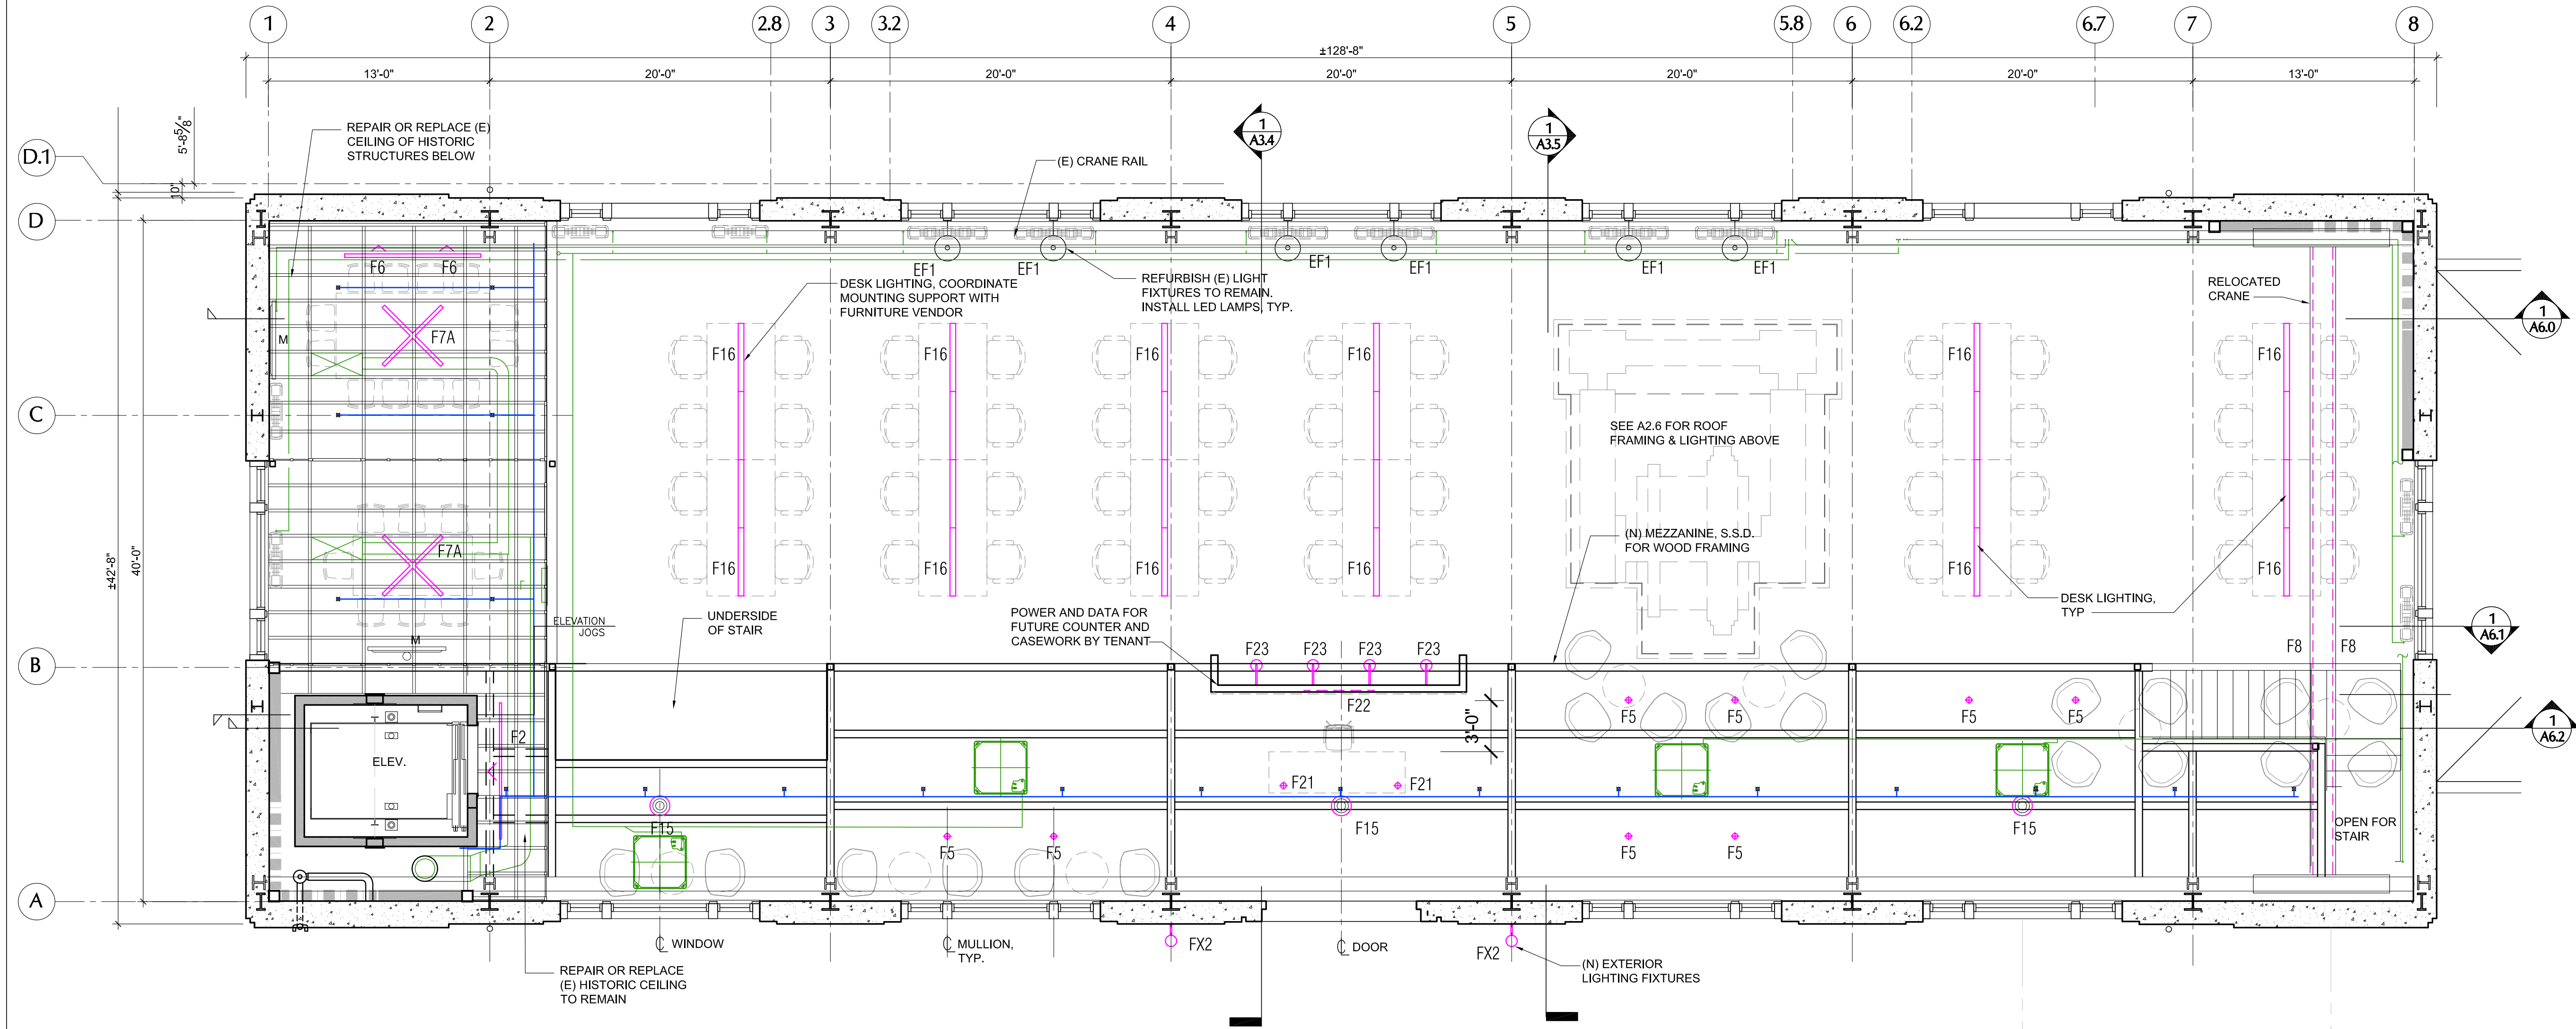

1 BUILDING 102 - MAIN LEVEL REFLECTED CEILING PLAN (Except for floor & desk lamps)
SEE F1.1 FOR FINISHES



SAN FRANCISCO PORT COMMISSION
PORT OF SAN FRANCISCO

Developer:
ORTON
DEVELOPMENT, INC.

1475 Powell Street, Suite 101
Emeryville, CA 94608
tel: 510.734.7605

Architect:
**MARCY WONG
DONN LOGAN
ARCHITECTS**

800 Bancroft Way, Suite 200
Berkeley, CA 94710
tel: 510.843.0916

Consultant:

Stamp:

PIER 70 SAN FRANCISCO
HISTORIC 20TH STREET BUILDINGS

Revisions:

Sheet Name:
**BLDG. 102 MAIN LEVEL
REFLECTED CEILING PLAN**

Phase: For Final Approval
Date: 24 September, 2018
By: MW, KR, KS, SB, LZ, SW

Building Number Sheet Number:

102 A2.5

LIGHTING LEGEND


- F1 LED SUSPENDED CYLINDER DOWNLIGHT
F2 LED LINEAR GRAZE
F3 LED TAPE LIGHT
F4 LED PAR W/ INTERCHANGEABLE LENSES
F5 LED PENDANT DOWNLIGHT
F6 LED LINEAR WALL WASH
F7 LED SUSPENDED LINEAR DIRECT/INDIRECT
F7A LED SUSPENDED LINEAR DIRECT/INDIRECT
F8 LED SURFACE MOUNTED TAPE LIGHT
F9 LED RECTANGULAR RED LIGHT WASH FIXTURE
F10 NOT USED
F11 LINEAR WALL MOUNTED DOWNLIGHT
F12 SURFACE MOUNTED WALL WASH DOWNLIGHT
F13 LED DOWNLIGHT PENDANT
F14 FLOOR LAMP (BY TENANT, FF & E)- SEE FLOOR PLANS
F15 PENDANT
F16 LED LINEAR TABLE LIGHT AT DESKS- COORDINATE WITH FURNITURE VENDOR
F17 LED DOWNLIGHT PENDANT
F18 RECTANGULAR VANITY LIGHT
F19 SURFACE MOUNTED LINEAR LED TAPE LIGHT
F20 SURFACE MOUNTED LED STRIP LIGHT
F21 DESK LAMP
F22 BACKLIT 'JUUL' SIGNAGE BY SIGNAGE CONTRACTOR
F23 WALL MOUNTED SIGN LIGHTS
F24 LED SUSPENDED CYLINDER DOWNLIGHT
F25 LED FLEXIBLE STRIP LIGHT- SEE FLOOR PLANS
EXISTING FIXTURES, REFURBISH AND INSTALL (N) LED LAMPS
• EF1 AT MAIN LEVEL WALL FIXTURES
• EF2 AT SUSPENDED MEZZANINE LEVEL FIXTURES
EXTERIOR:
FX1 WALL MOUNTED LED DIRECT LIGHT
FX2 WALL MOUNTED LED
FX3 LED FLEXIBLE STRIP- SEE FLOOR PLANS
FX4 NOT USED
FX5 HANDRAIL WITH INTEGRATED LED LIGHTING- SEE 1/A2.1
FX6 LED BOLLARD- SEE 1/A2.1

NOTES


- ELECTRICAL ENGINEER TO PROVIDE CIRCUITING, EMERGENCY EGRESS LIGHTING DESIGN AND TITLE 24 COMPLIANCE DOCUMENTATION
- SEE SECTIONS AND INTERIOR ELEVATIONS FOR MOUNTING HEIGHTS. CONSULT ARCHITECT WHERE NOT SHOWN
- SEE FLOOR PLANS FOR F14 FLOOR LAMP AND LIGHTING AT DECK, STAIRS AND LANDSCAPING
- EMERGENCY LIGHTING AND TITLE 24 BY ELECTRICAL ENGINEER

CEILING PLAN LEGEND

- NEW VERTICAL BRACE FRAME, S.S.D.
NEW BEAMS, S.S.D.
WOOD INFILL AT (E) OPENING.
MECHANICAL PIPING
FIRE SPRINKLER PIPING
FIRE SPRINKLER

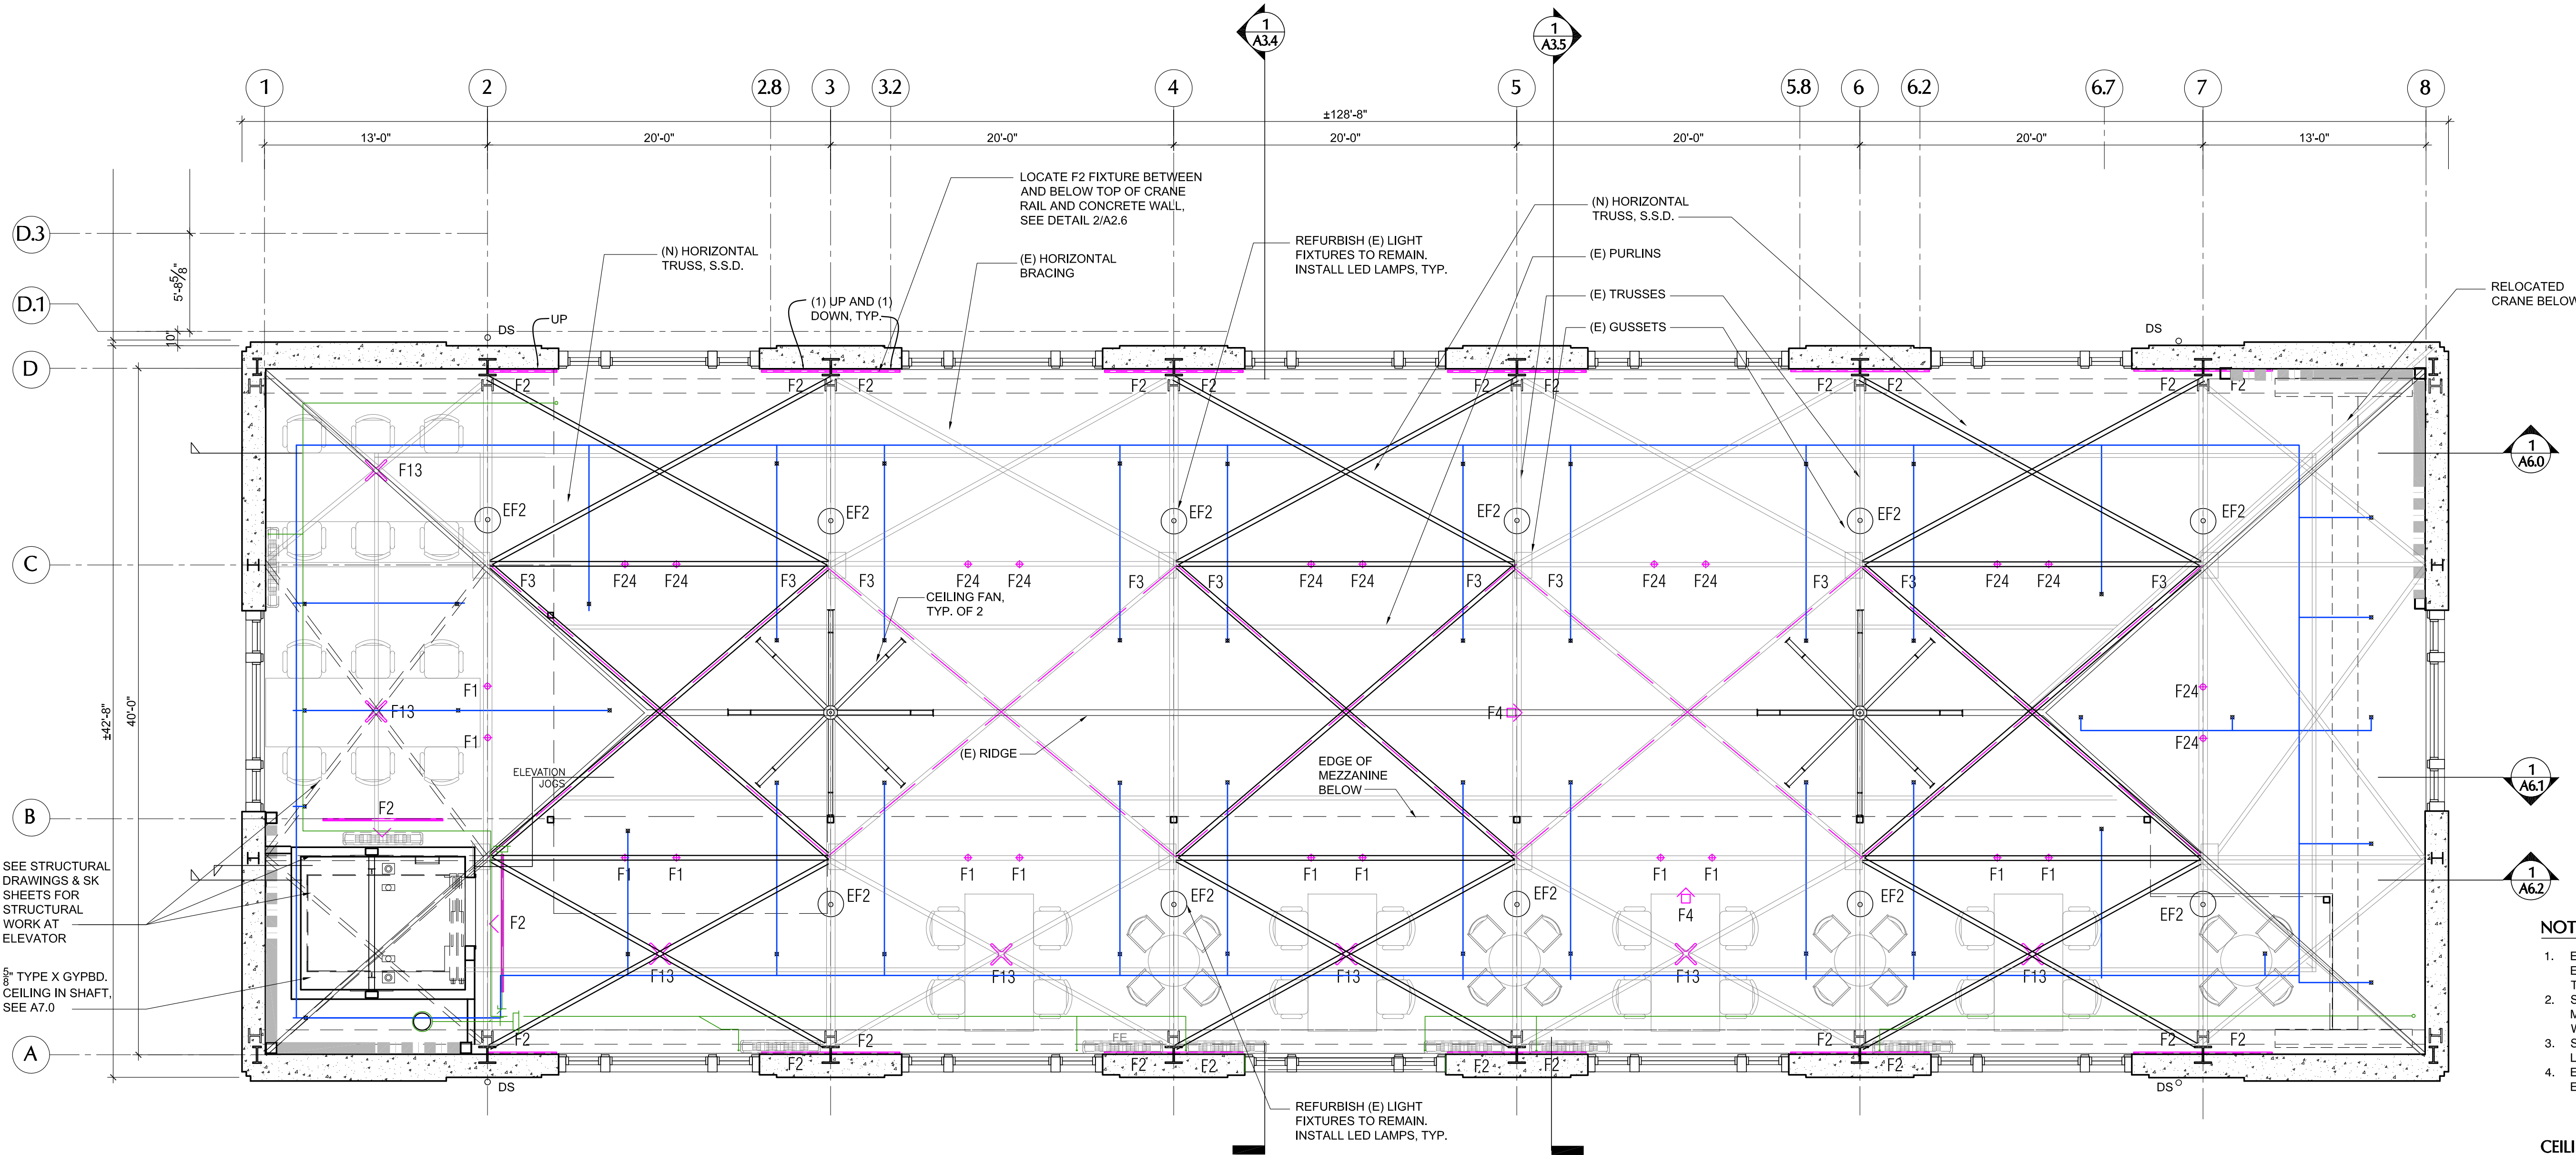

 1 BUILDING 102 - MEZZANINE LEVEL REFLECTED CEILING PLAN (Except for floor & desk lamps)
SEE F1.2 FOR FINISHES



SAN FRANCISCO PORT COMMISSION
PORT OF SAN FRANCISCO

Developer:
ORTON
DEVELOPMENT, INC.

1475 Powell Street, Suite 101
Emeryville, CA 94608
tel: 510.734.7605

Architect:
MARCY WONG
DONN LOGAN
ARCHITECTS

800 Bancroft Way, Suite 200
Berkeley, CA 94710
tel: 510.843.0916

Consultant:

Stamp:

PIER 70 SAN FRANCISCO
HISTORIC 20TH STREET BUILDINGS


Revisions:

Sheet Name:
BLDG. 102 MEZZANINE LEVEL
REFLECTED CEILING PLAN

Phase: For Final Approval
Date: 24 September, 2018
By: MW, KR, KS, SB, LZ, SW


Building Number Sheet Number

102 A2.6

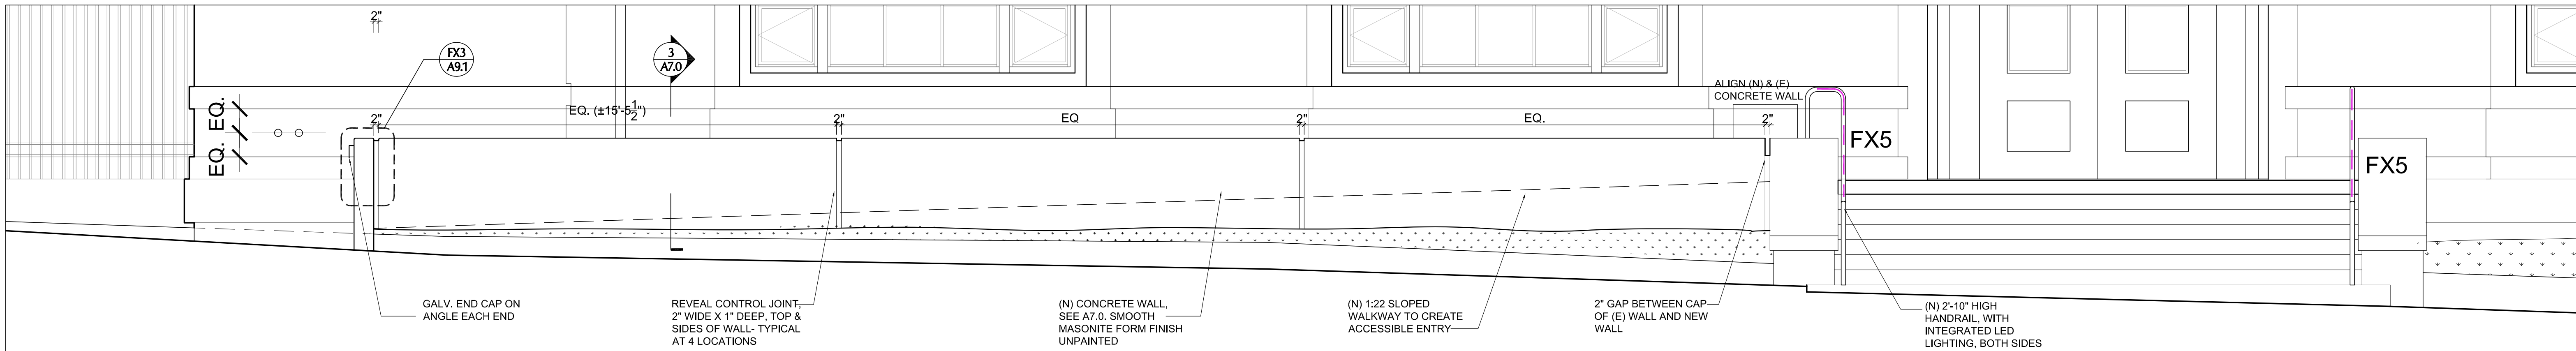

2 BUILDING 102 - LOW WALL AT SOUTH EXTERIOR ELEVATION

0 2' 4' 8' 3/16" = 1'-0" AT FULL SIZE (22"X34" PAPER SIZE)

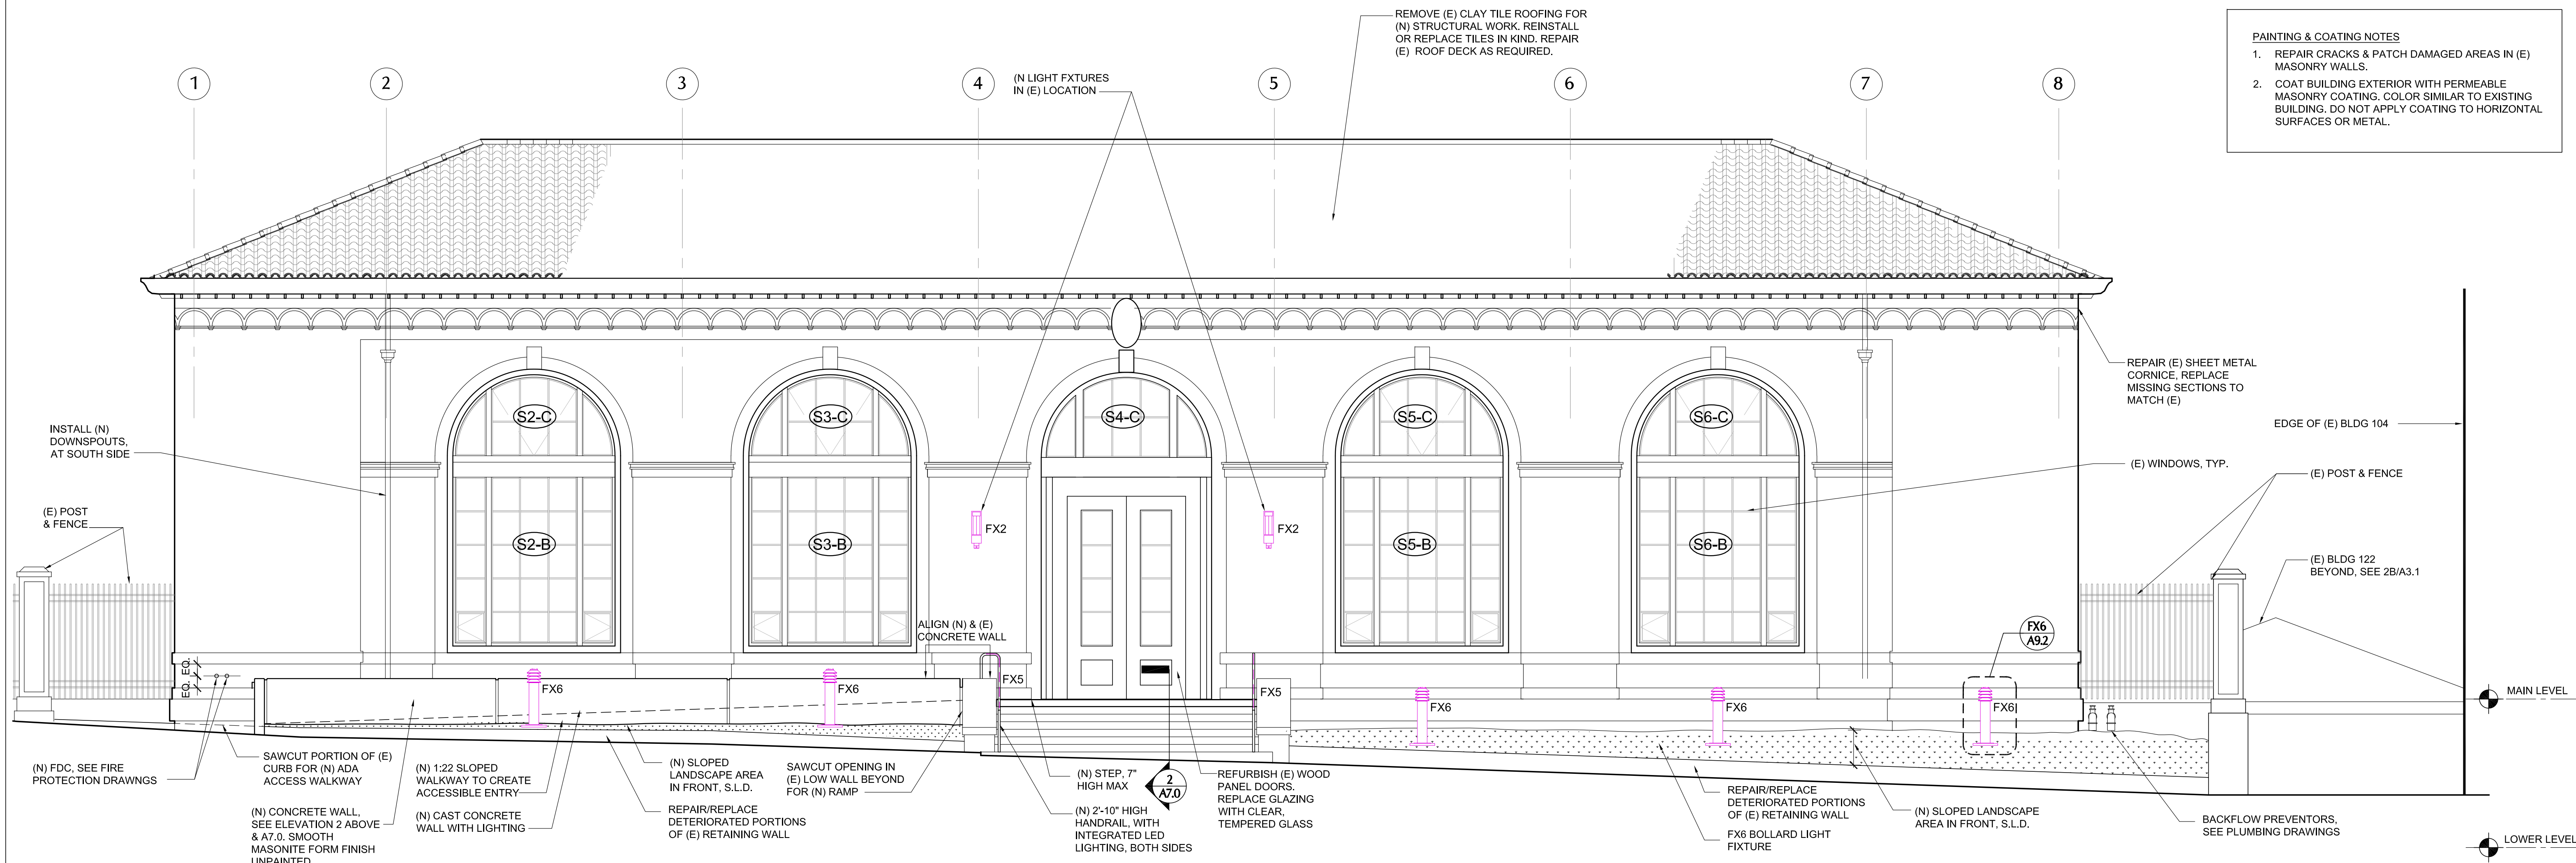

PAINTING & COATING NOTES

1. REPAIR CRACKS & PATCH DAMAGED AREAS IN (E) MASONRY WALLS.
2. COAT BUILDING EXTERIOR WITH PERMEABLE MASONRY COATING. COLOR SIMILAR TO EXISTING BUILDING. DO NOT APPLY COATING TO HORIZONTAL SURFACES OR METAL.


1 BUILDING 102 - SOUTH EXTERIOR ELEVATION

0 2' 4' 8' 3/16" = 1'-0" AT FULL SIZE (22"X34" PAPER SIZE)


 SAN FRANCISCO PORT COMMISSION PORT OF SAN FRANCISCO	Developer: ORTON DEVELOPMENT, INC. 1475 Powell Street, Suite 101 Emeryville CA 94608 tel: 510.734.7605	Architect: MARCY WONG DONN LOGAN ARCHITECTS 800 Bancroft Way, Suite 200 Berkeley, CA 94710 tel: 510.843.0916	Consultant:	Stamp:	PIER 70 SAN FRANCISCO HISTORIC 20TH STREET BUILDINGS	Revisions:	Sheet Name: BLDG. 102 SOUTH EXTERIOR ELEVATION Phase: For Final Approval Date: 24 September, 2018 By: MW, KR, KS, SB, LZ, SW	Building Number: 102 Sheet Number: A3.0
---	---	---	------------------------	-------------------	--	---	--	---

N:\JOBS\1210 Pier 70\CD & Permit REV & HPCA\102\DD1210 Bldg 102-A3 Elev.dwg, 9/20/2018 3:57:04 PM

- PAINTING & COATING NOTES**
1. REPAIR CRACKS & PATCH DAMAGED AREAS IN (E) MASONRY WALLS.
 2. COAT BUILDING EXTERIOR WITH PERMEABLE MASONRY COATING, COLOR SIMILAR TO EXISTING BUILDING. DO NOT APPLY COATING TO HORIZONTAL SURFACES OR METAL.

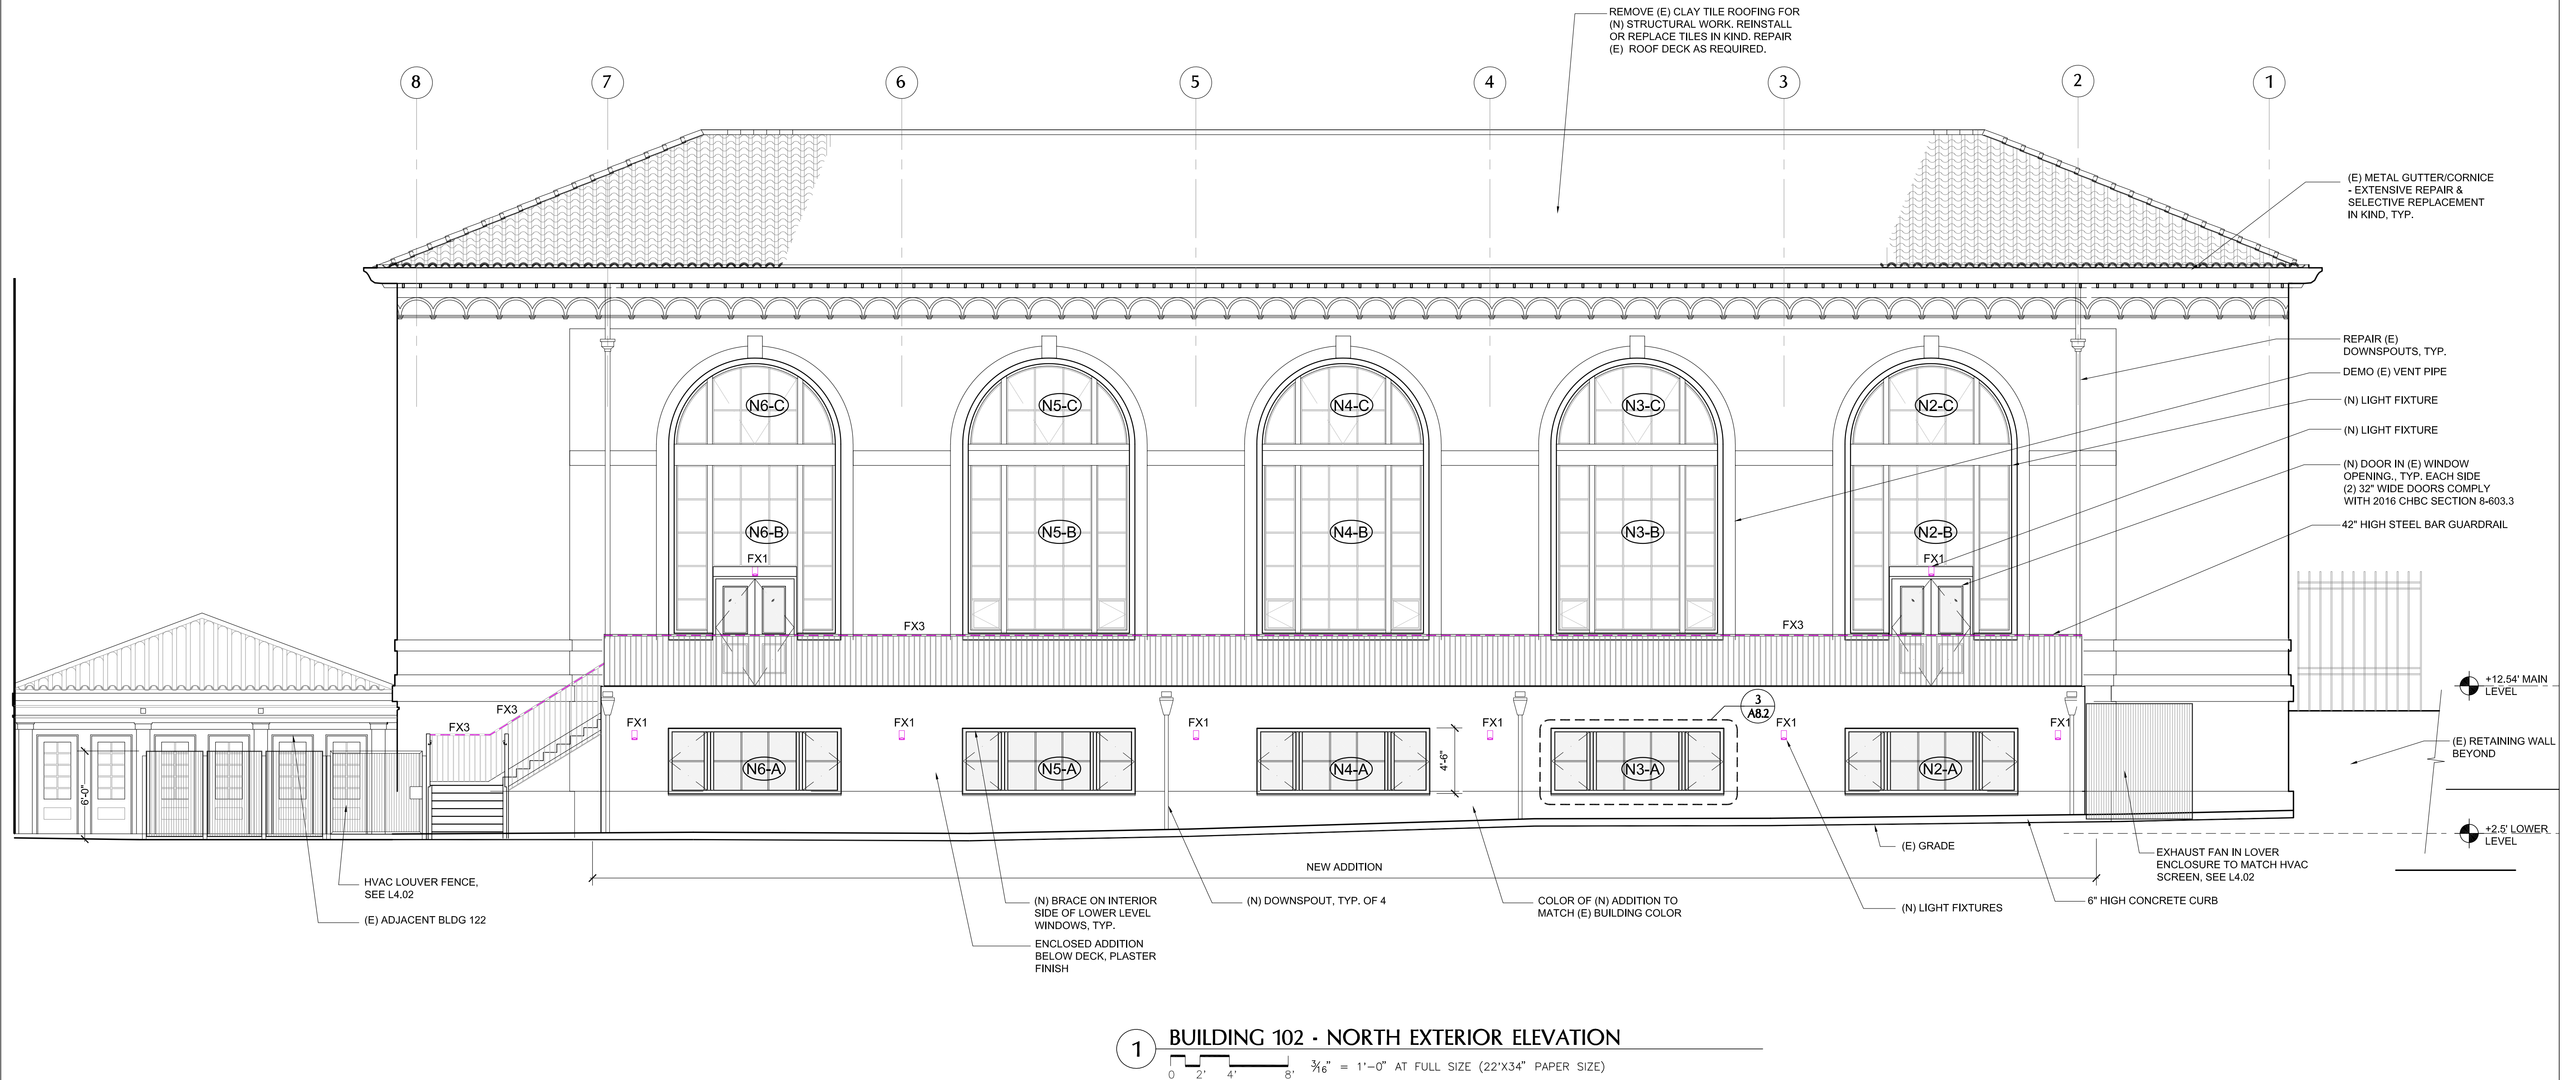

 1 BUILDING 102 - NORTH EXTERIOR ELEVATION



SAN FRANCISCO PORT COMMISSION
PORT OF SAN FRANCISCO

Developer:
ORTON
DEVELOPMENT, INC.

1475 Powell Street, Suite 101
Emeryville CA 94608
tel: 510.734.7605

Architect:

MARCY WONG
DONN LOGAN
ARCHITECTS

800 Bancroft Way, Suite 200
Berkeley, CA 94710
tel. 510.843.0916

Consultant:

Stamp:

PIER 70 SAN FRANCISCO

HISTORIC 20TH STREET BUILDINGS

Revisions:


Sheet Name:
BLDG. 102 NORTH
EXTERIOR ELEVATION

<i>Phase:</i>	For Final Approval
<i>Date:</i>	24 September, 2018
<i>By:</i>	MW, KR, KS, SB, LZ, SW

<i>Building Number:</i>	<i>Sheet Number:</i>
-----------------------------	--------------------------


102 A3.1

N:\JOBS\1210 Pier 70\CD & Permit\REV & HPCA\102\DD\1210 Bldg 102-A3 Elev.dwg, 9/20/2018 3:58:42 PM

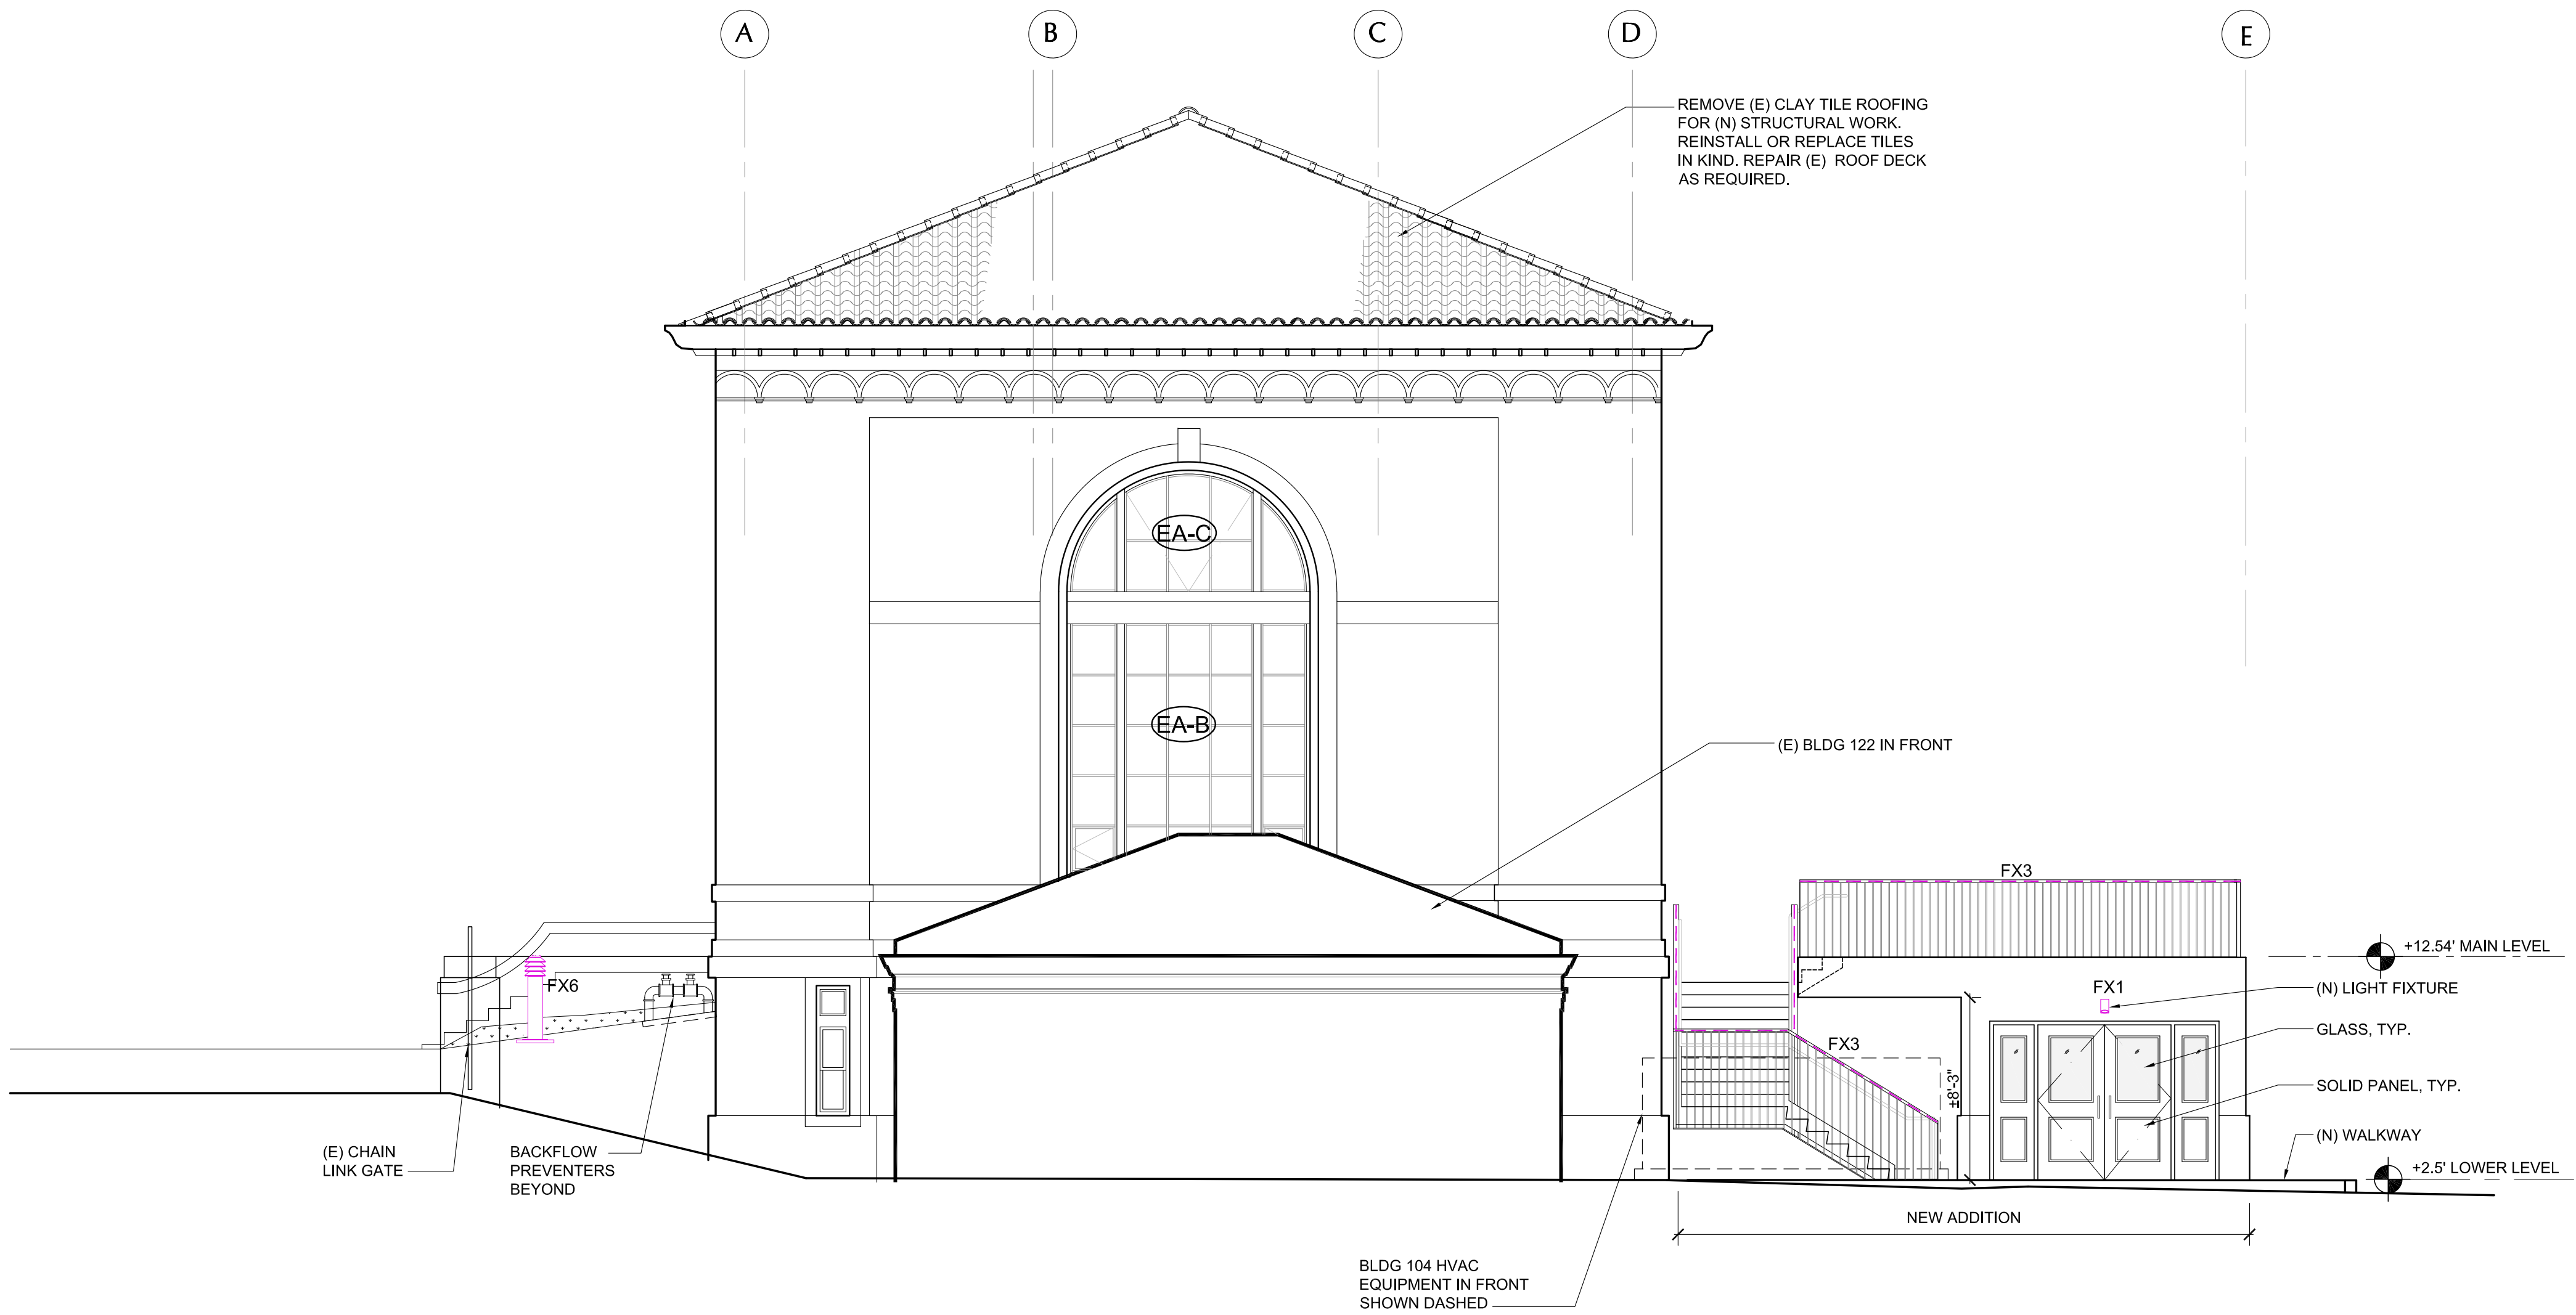


1 BUILDING 102 - EAST EXTERIOR ELEVATION
0 2' 4' 8' 3/16" = 1'-0" AT FULL SIZE (22"X34" PAPER SIZE)

 SAN FRANCISCO PORT COMMISSION PORT OF SAN FRANCISCO	<i>Developer:</i> ORTON DEVELOPMENT, INC.	<i>Architect:</i> MARCY WONG DONN LOGAN ARCHITECTS	<i>Consultant:</i>	<i>Stamp:</i>	PIER 70 SAN FRANCISCO HISTORIC 20TH STREET BUILDINGS	<i>Revisions:</i> 	<i>Sheet Name:</i> BLDG. 102 EAST EXTERIOR ELEVATIONS	Building Number 102 Sheet Number A3.3
	1475 Powell Street, Suite 101 Emeryville CA 94608 tel: 510.734.7605	800 Bancroft Way, Suite 200 Berkeley, CA 94710 tel: 510.843.0916					<i>Phase:</i> For Final Approval	
							<i>Date:</i> 24 September, 2018 <i>By:</i> MW, KR, KS, SB, LZ, SW	

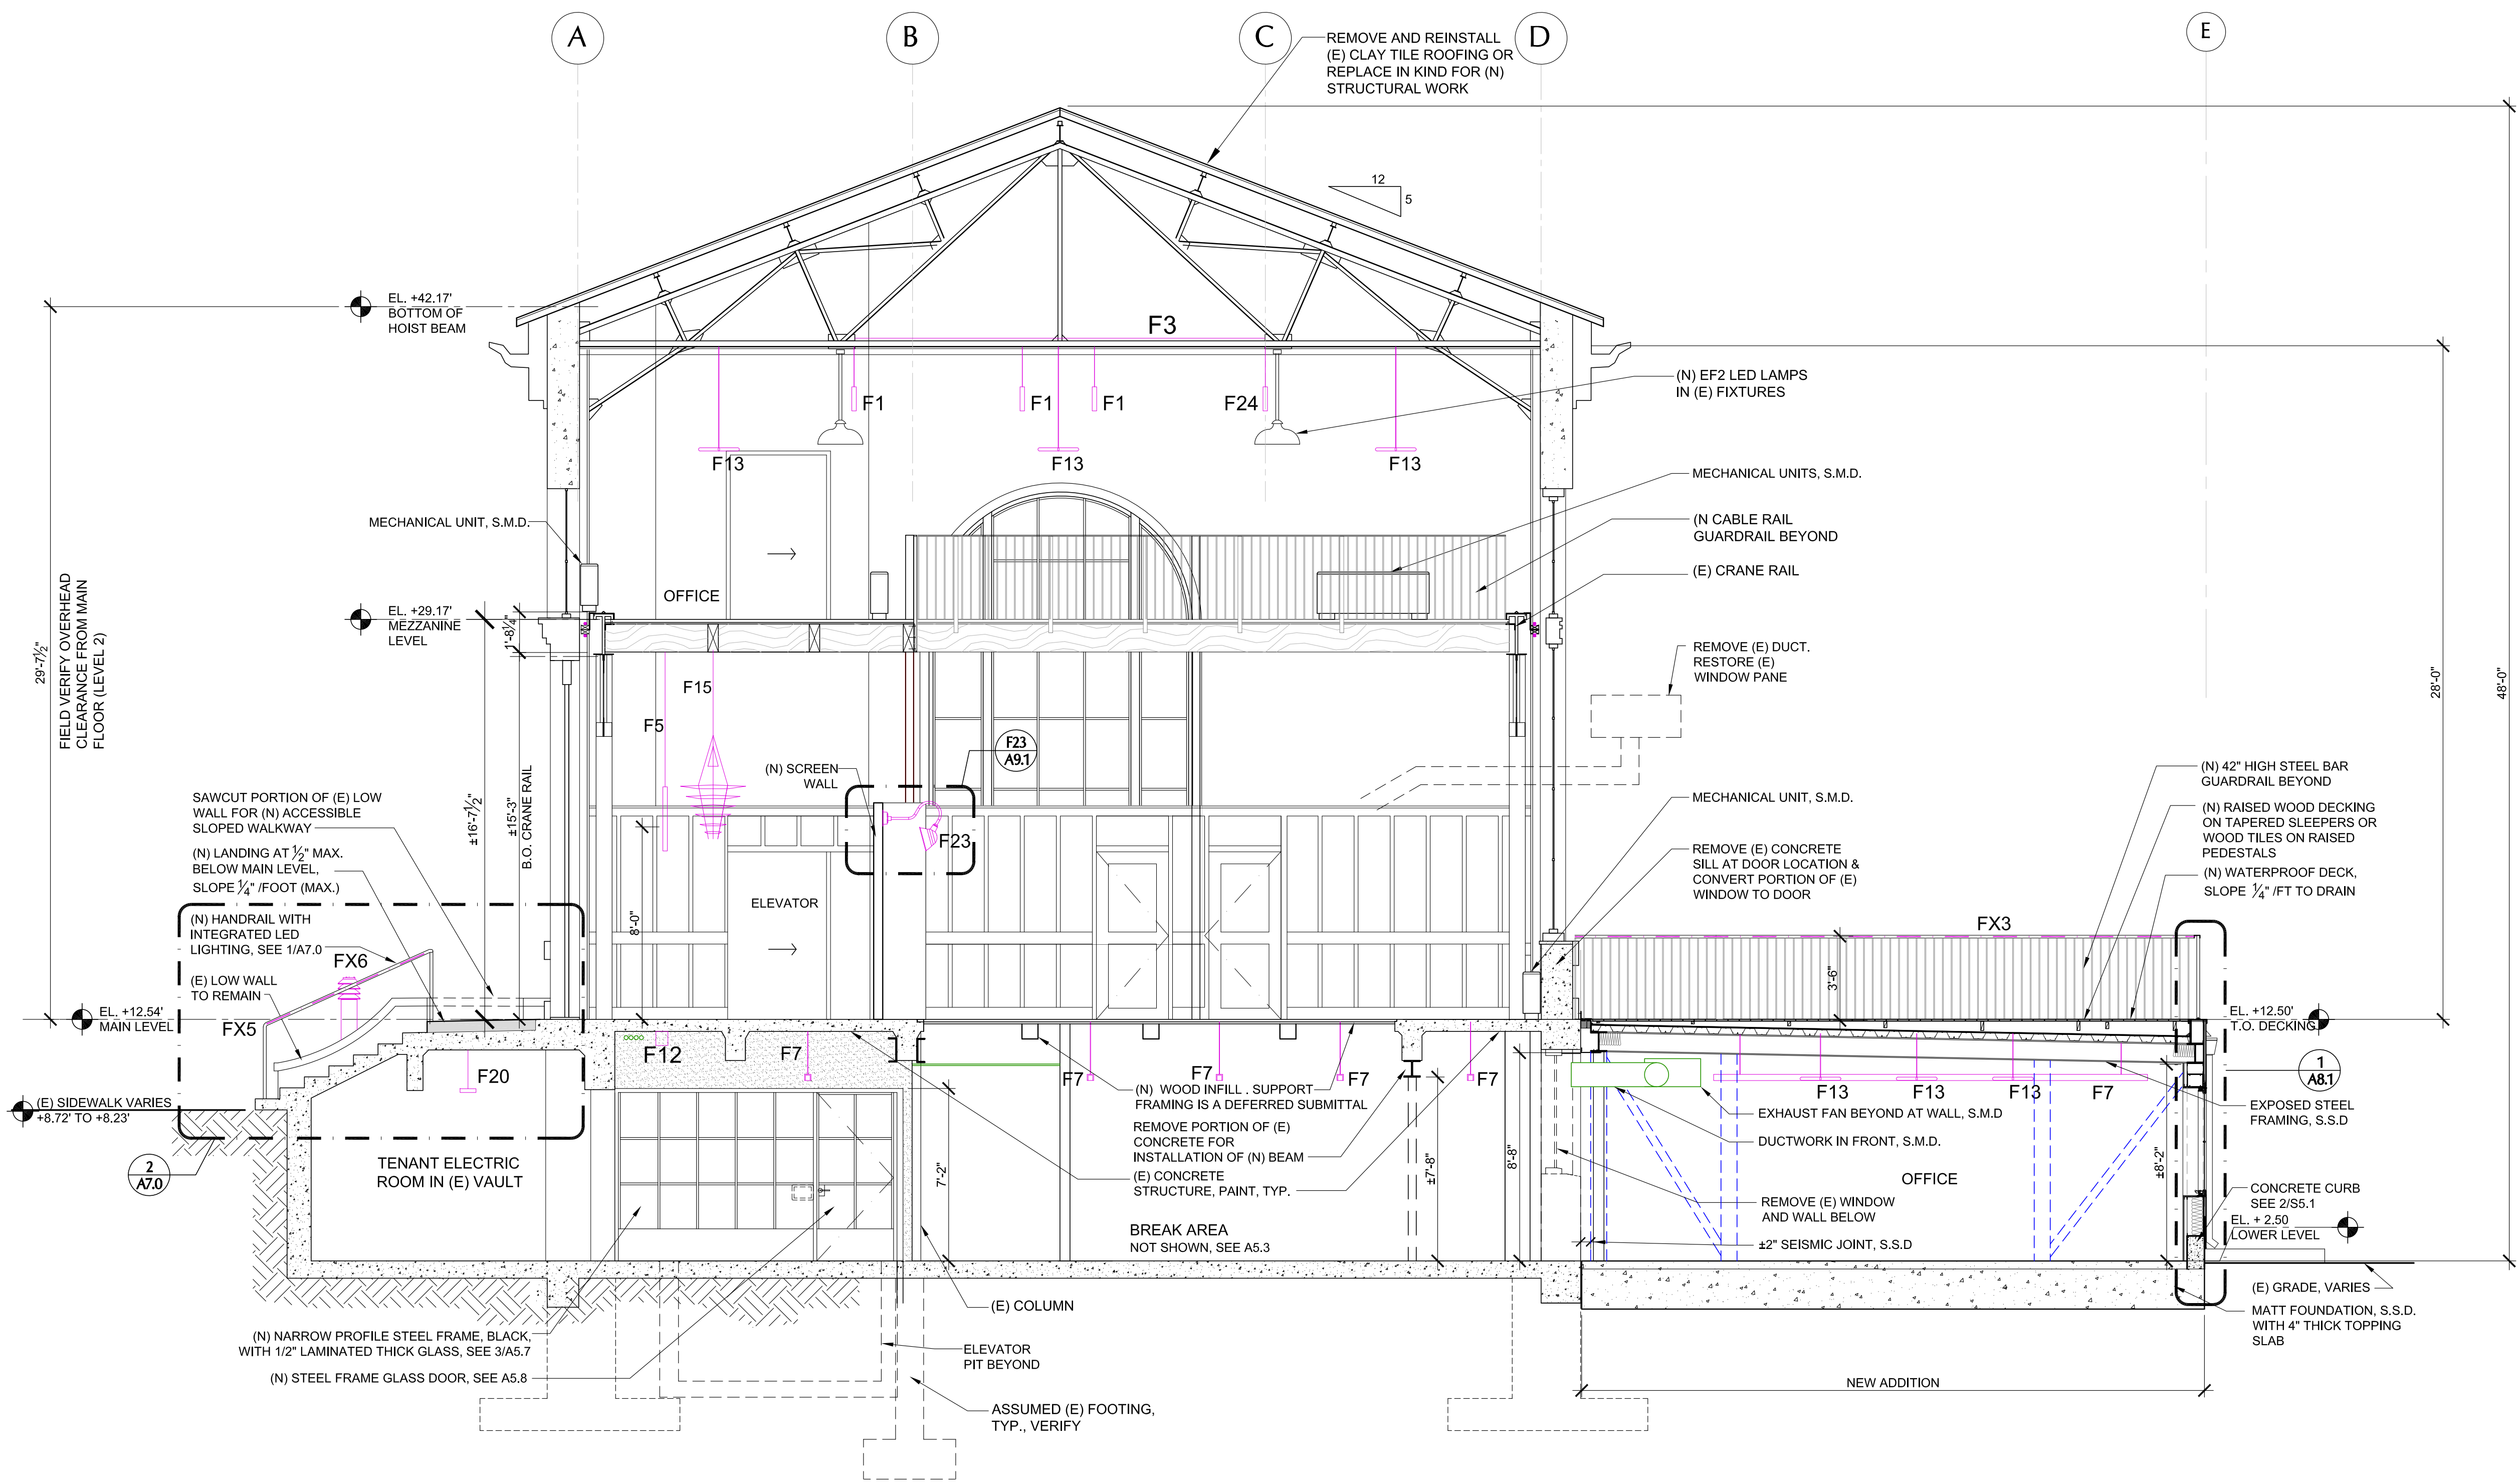

1 BUILDING 102 - CROSS SECTION LOOKING WEST
0 1' 2' 4' 8' 1/4" = 1'-0" AT FULL SIZE (22"X34" PAPER SIZE)

 SAN FRANCISCO PORT COMMISSION PORT OF SAN FRANCISCO	Developer: ORTON DEVELOPMENT, INC. 1475 Powell Street, Suite 101 Emeryville, CA 94608 tel: 510.734.7605	Architect: MARCY WONG DONN LOGAN ARCHITECTS 800 Bancroft Way, Suite 200 Berkeley, CA 94710 tel: 510.843.0916	Consultant:	Stamp:	PIER 70 SAN FRANCISCO HISTORIC 20TH STREET BUILDINGS	Revisions: 	Sheet Name: BLDG. 102 CROSS SECTION LOOKING WEST Phase: For Final Approval Date: 24 September, 2018 By: MW, KR, KS, SB, LZ, SW	Building Number: 102 Sheet Number: A3.4

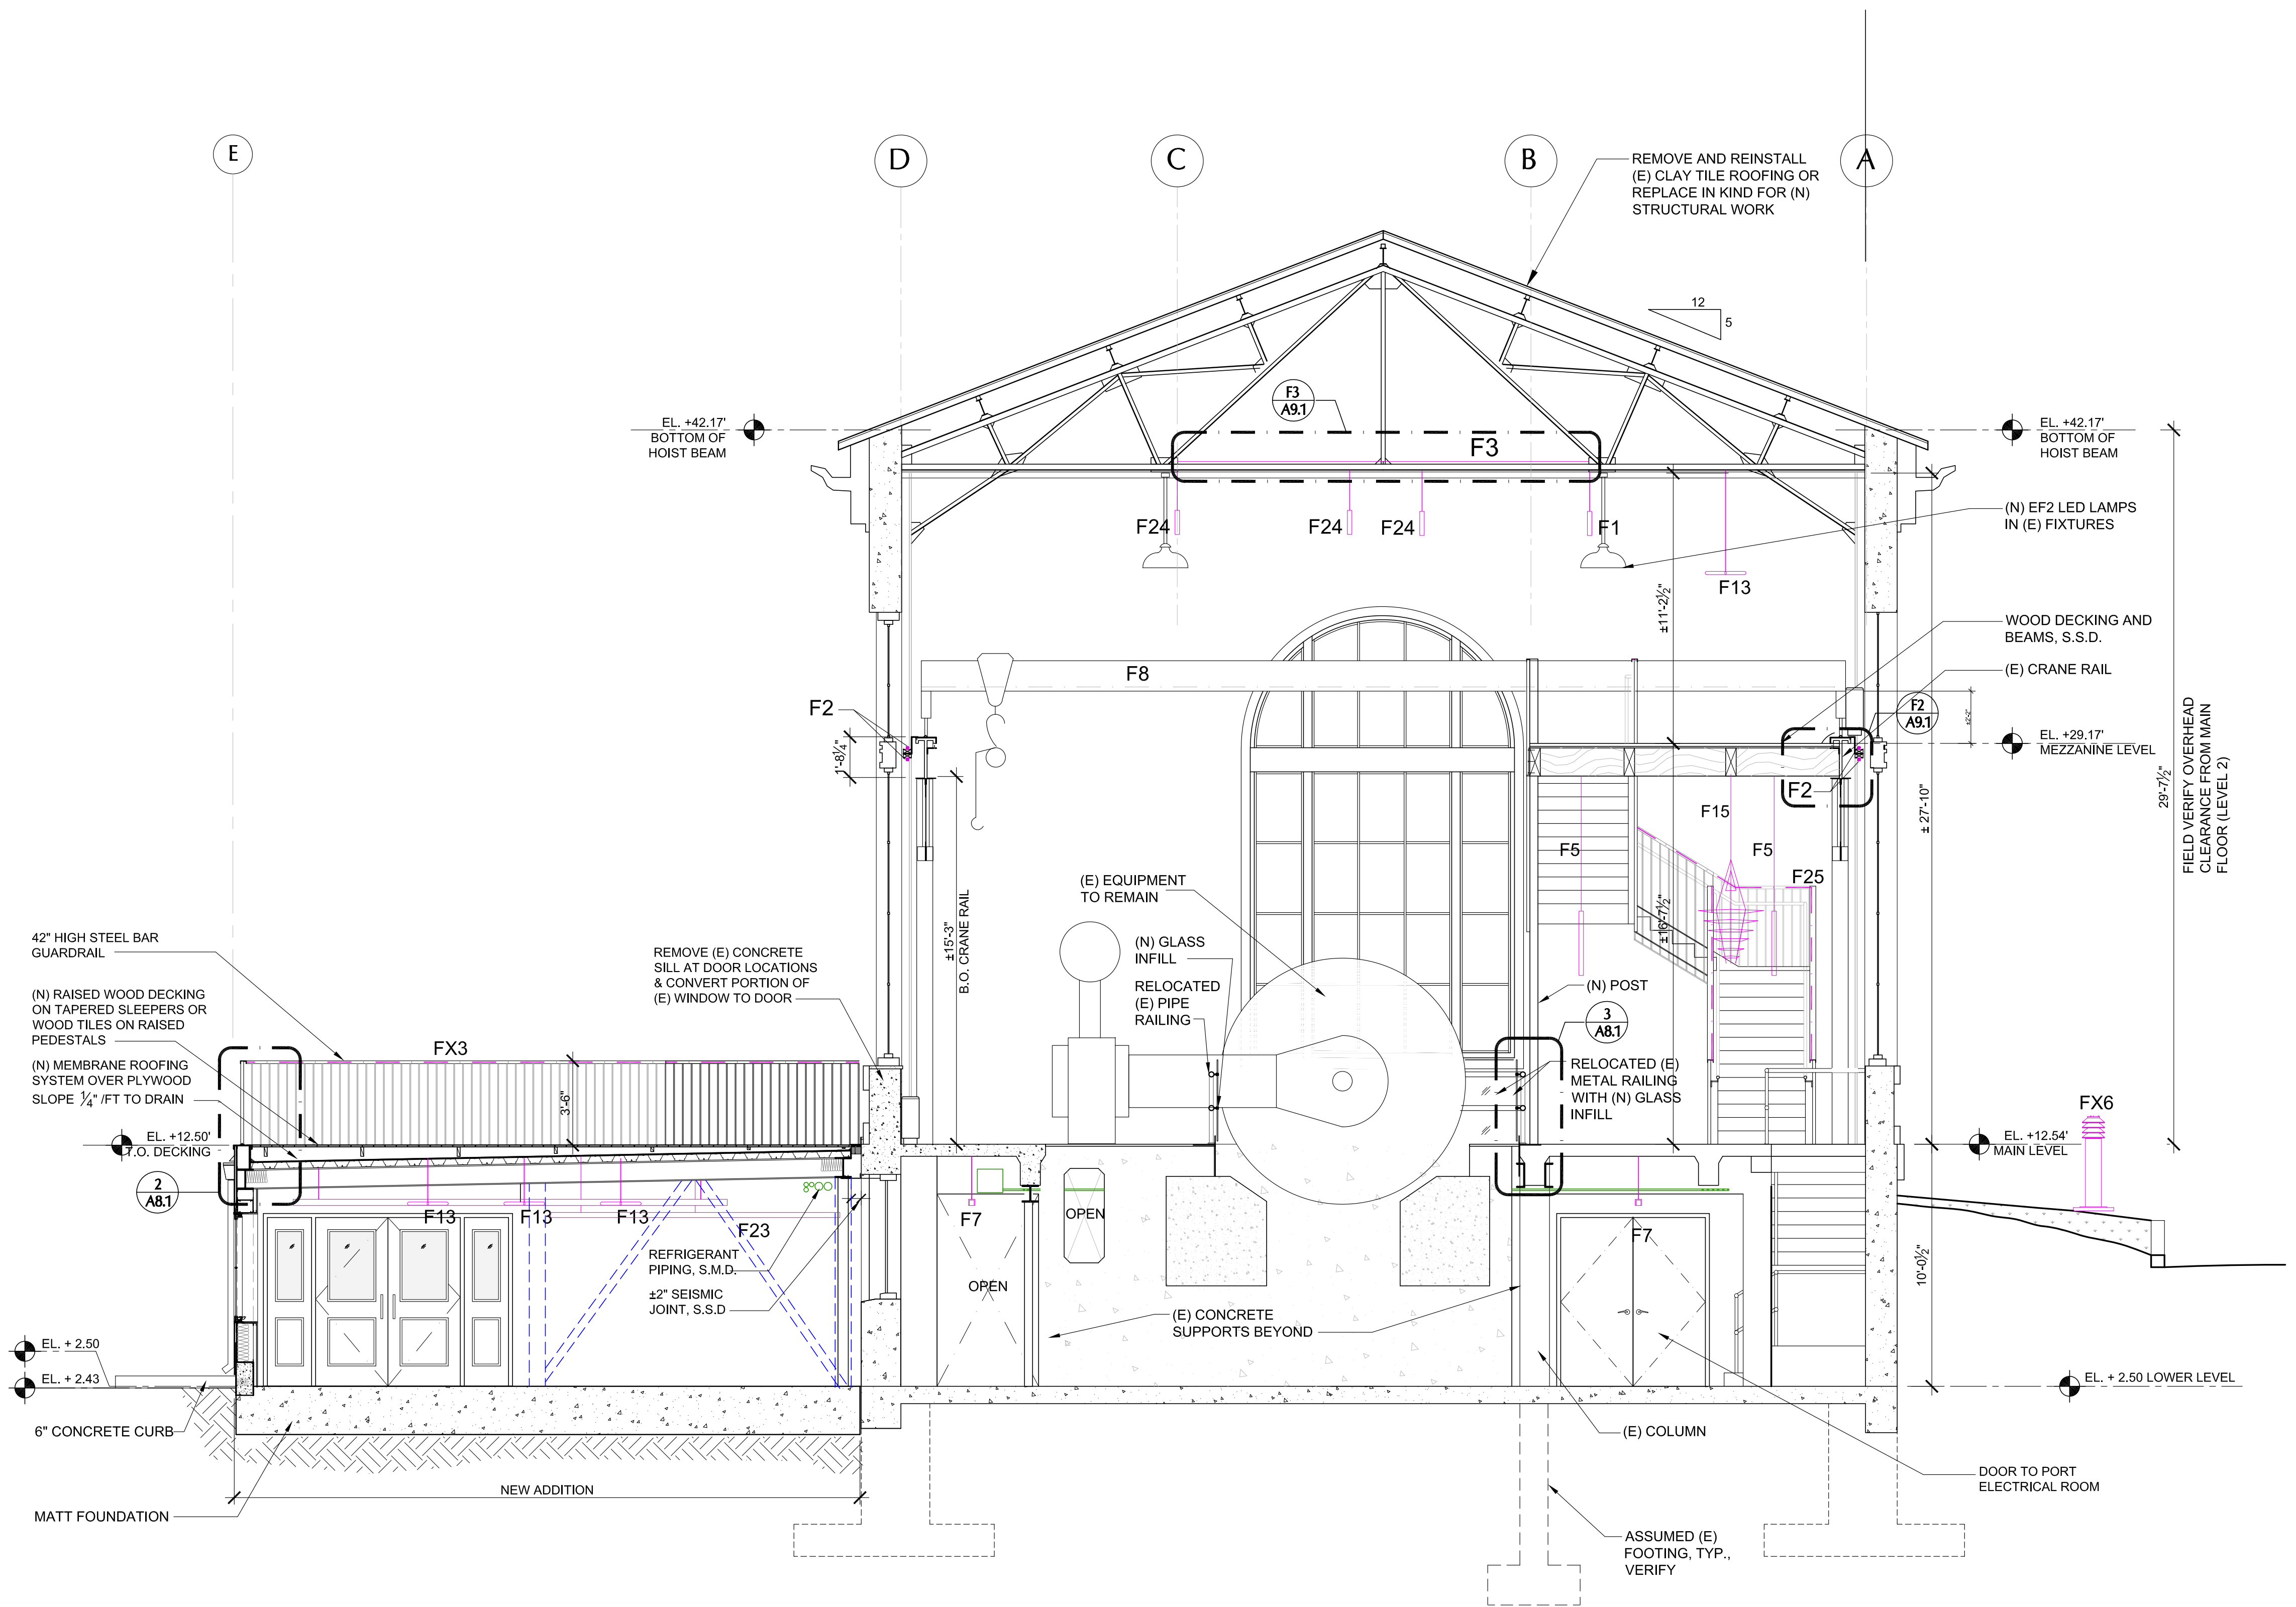

1 BUILDING 102 - CROSS SECTION LOOKING EAST
0 1' 2' 4' 8' 1/4" = 1'-0" AT FULL SIZE (22"X34" PAPER SIZE)



SAN FRANCISCO PORT COMMISSION
PORT OF SAN FRANCISCO

Developer:
ORTON
DEVELOPMENT, INC.

1475 Powell Street, Suite 101
Emeryville, CA 94608
tel: 510.734.7605

Architect:
MARCY WONG
DONN LOGAN
ARCHITECTS

800 Bancroft Way, Suite 200
Berkeley, CA 94710
tel: 510.843.0916

Consultant:

Stamp:

PIER 70 SAN FRANCISCO


HISTORIC 20TH STREET BUILDINGS

Revisions:


Sheet Name:
**BLDG. 102 CROSS SECTION
LOOKING EAST**

Phase: For Final Approval
Date: 24 September, 2018
By: MW, KR, KS, SB, LZ, SW


Building Number: 102
Sheet Number: A3.5

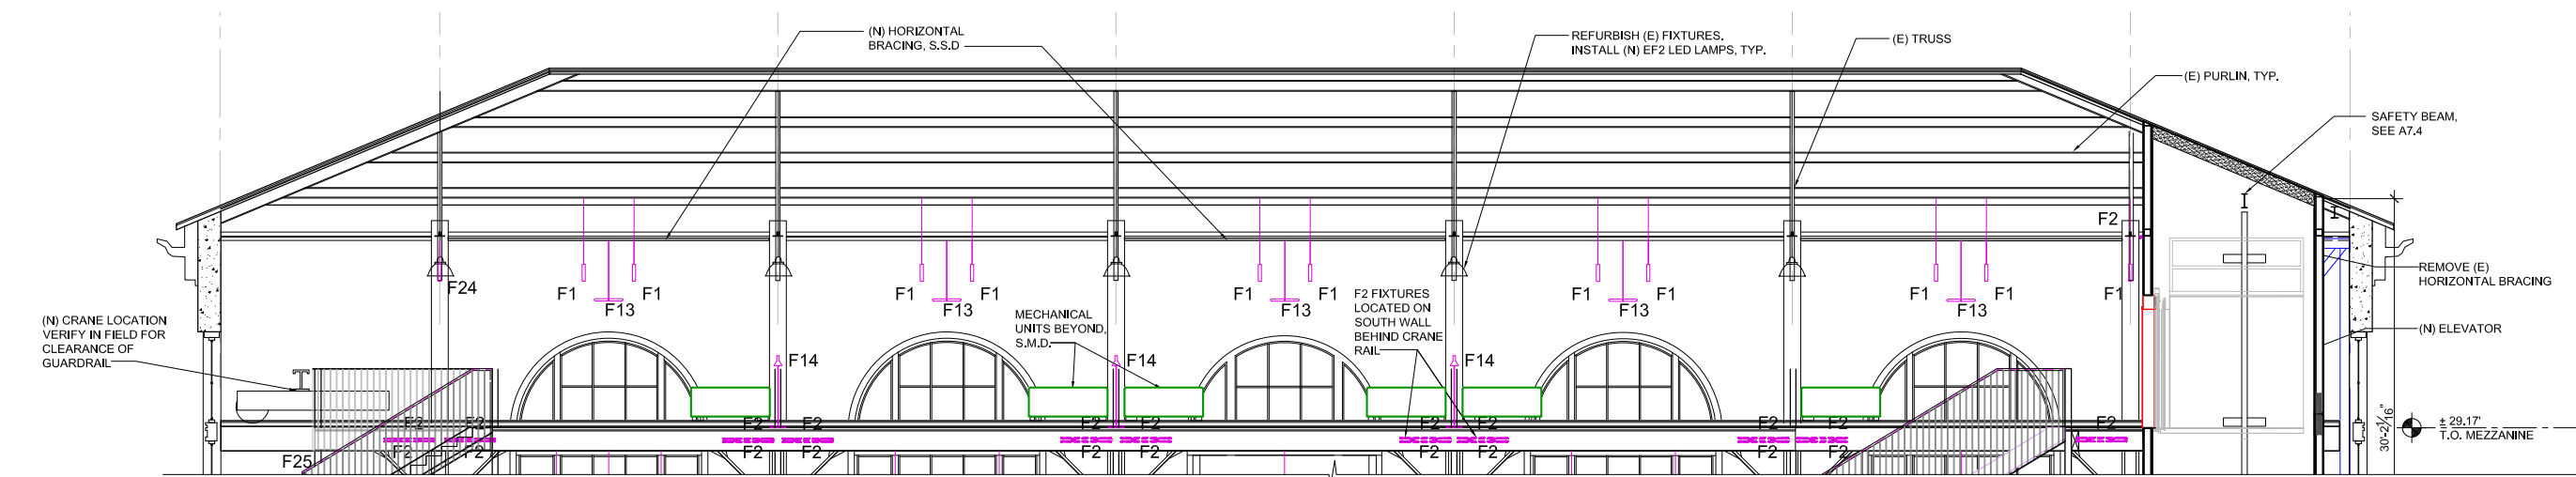


2 BUILDING 102 - INTERIOR ELEVATION MEZZANINE LEVEL
 0 2' 4' 8' 3/16" = 1'-0" AT FULL SIZE (22"X34" PAPER SIZE)

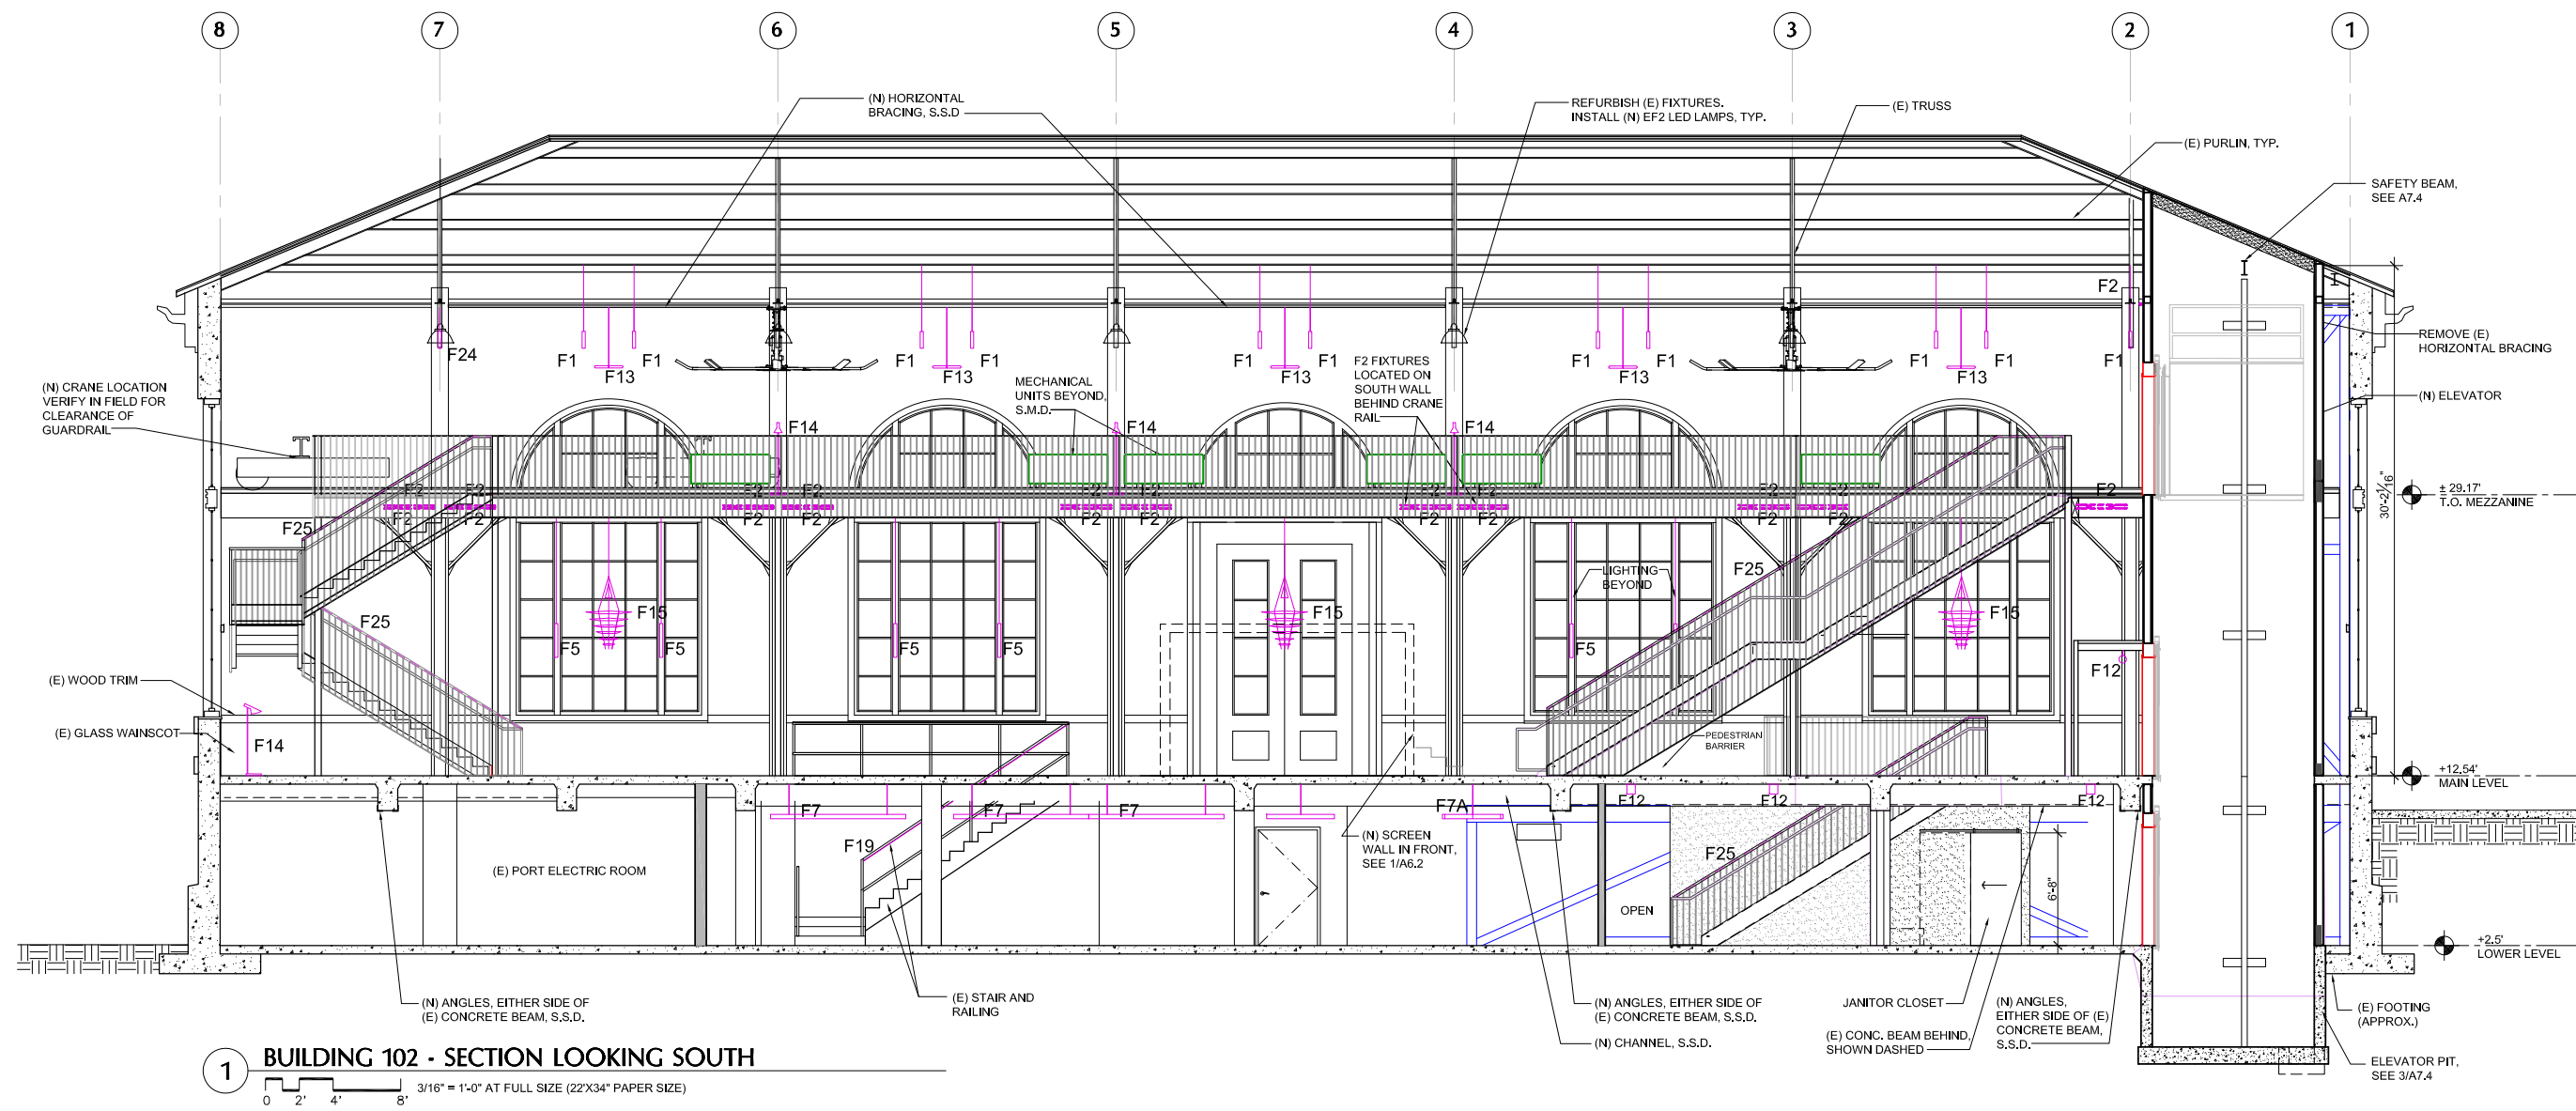

1 BUILDING 102 - SECTION LOOKING SOUTH
 0 2' 4' 8' 3/16" = 1'-0" AT FULL SIZE (22"X34" PAPER SIZE)

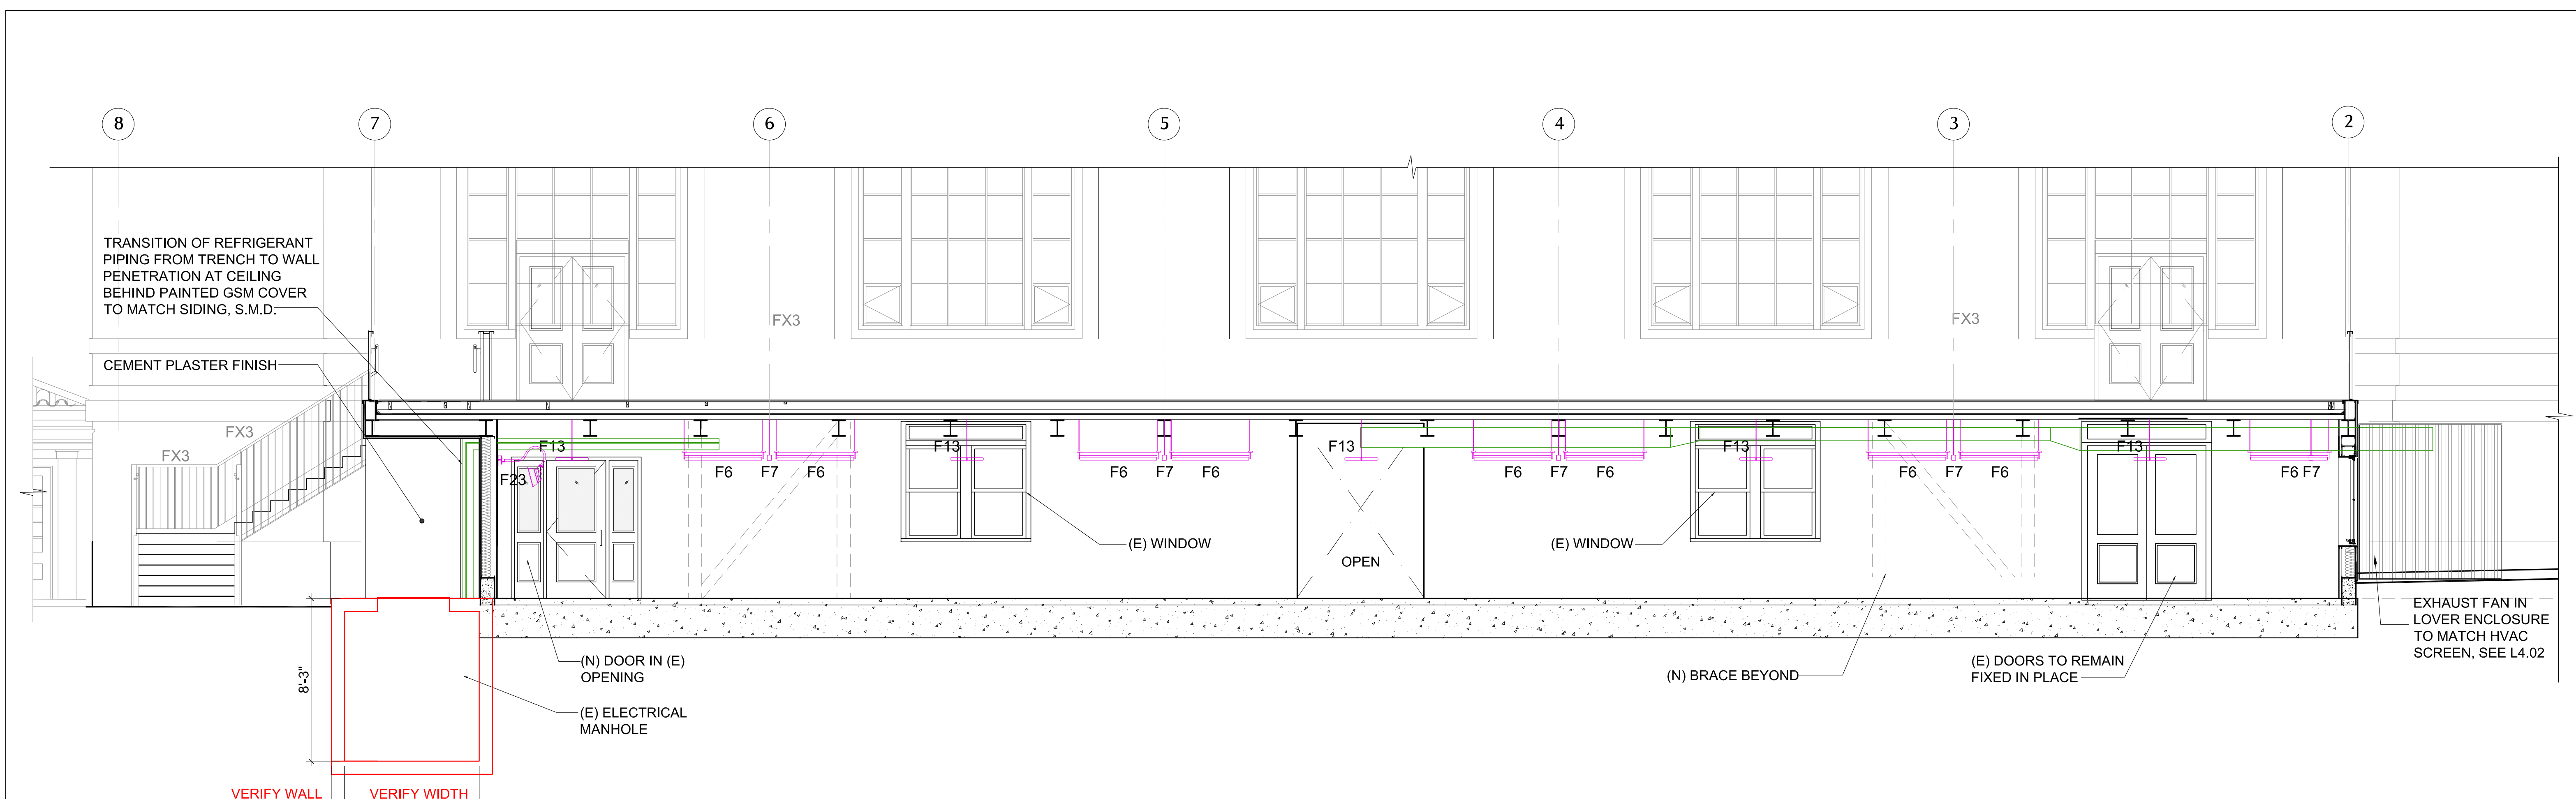


2 BUILDING 102 - ADDITION NORTH INTERIOR ELEVATION / SECTION
0' 1' 2' 4' 8' 1/4" = 1'-0" AT FULL SIZE (22"X34" PAPER SIZE)

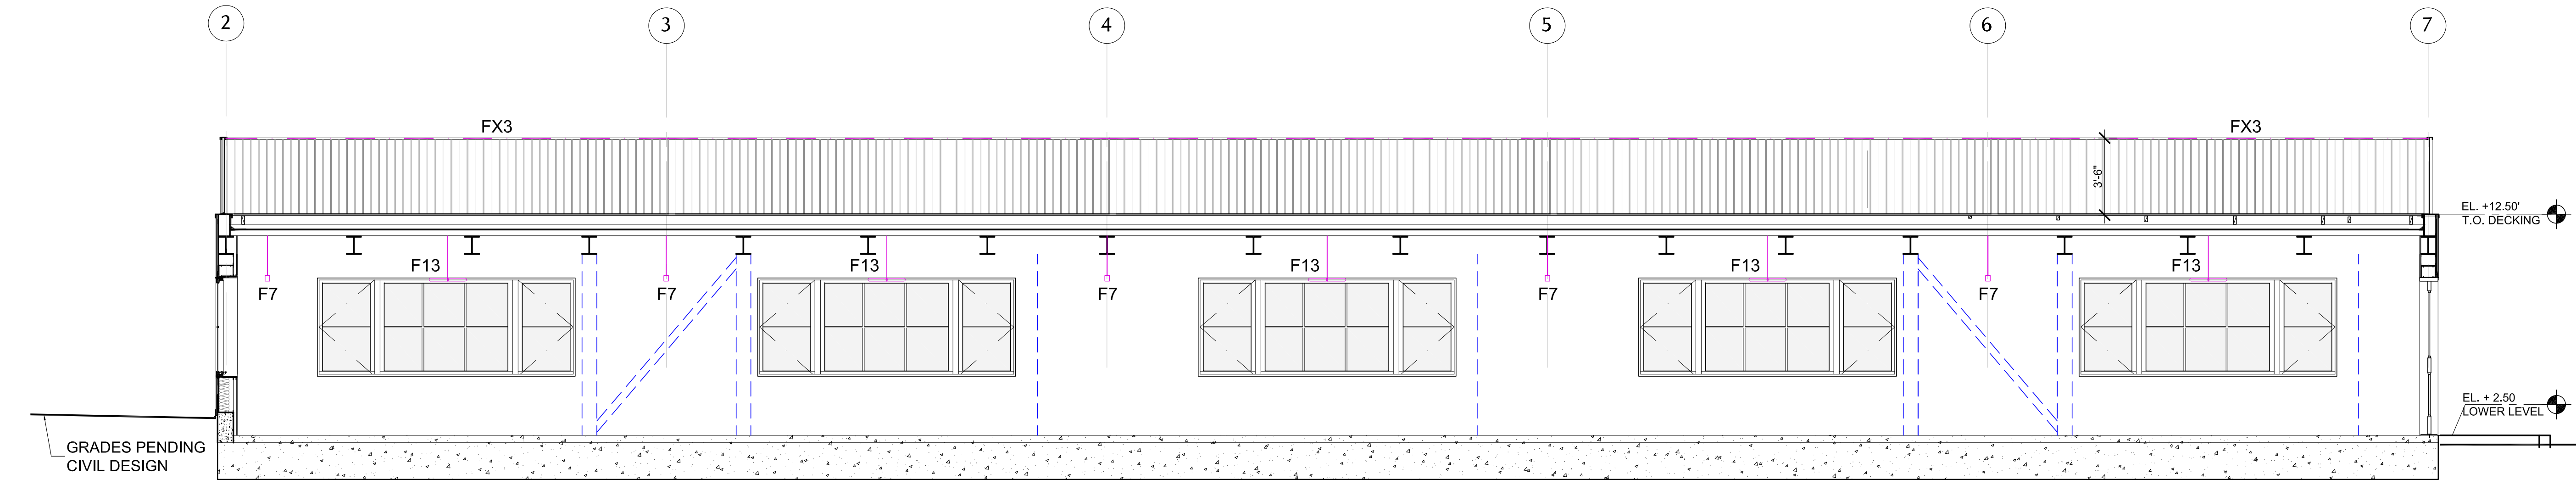


1 BUILDING 102 - ADDITION SOUTH INTERIOR ELEVATION / SECTION
0' 1' 2' 4' 8' 1/4" = 1'-0" AT FULL SIZE (22"X34" PAPER SIZE)

 SAN FRANCISCO PORT COMMISSION PORT OF SAN FRANCISCO	Developer: ORTON DEVELOPMENT, INC. 1475 Powell Street, Suite 101 Emeryville, CA 94608 tel: 510.734.7605	Architect: MARCY WONG DONN LOGAN ARCHITECTS 800 Bancroft Way, Suite 200 Berkeley, CA 94710 tel: 510.843.0916	Consultant:	Stamp:	PIER 70 SAN FRANCISCO HISTORIC 20TH STREET BUILDINGS	Revisions: _____ _____ _____ _____ _____	Sheet Name: BLDG. 102 ADDITION INTERIOR ELEVATIONS / SECTIONS Phase: For Final Approval Date: 24 September, 2018 By: MW, KR, KS, SB, LZ, SW	Building Number: 102 Sheet Number: A6.3


N:\JOBS\1210 Pier 70\CD & Permit\REV & HPCA\102\DD\1210 Bldg 102-A9.1 Lighting Fixture Details.dwg, 9/20/2018 2:55:40 PM

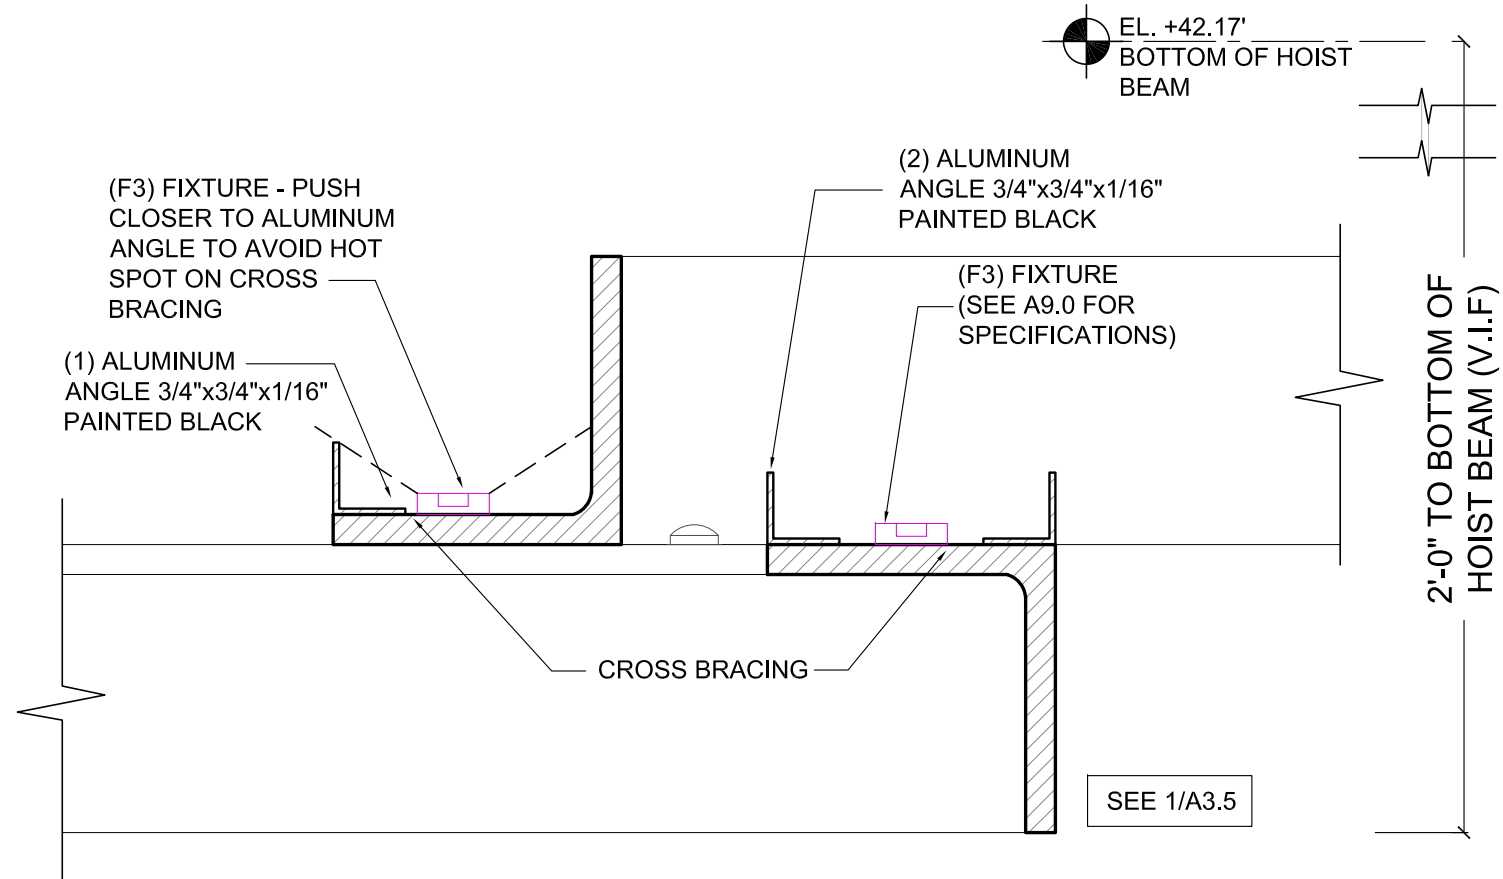


F3 LED TAPE LIGHT ATOP "X" CROSS BRACING
6"= 1'-0" AT FULL SIZE (22'X34" PAPER SIZE)

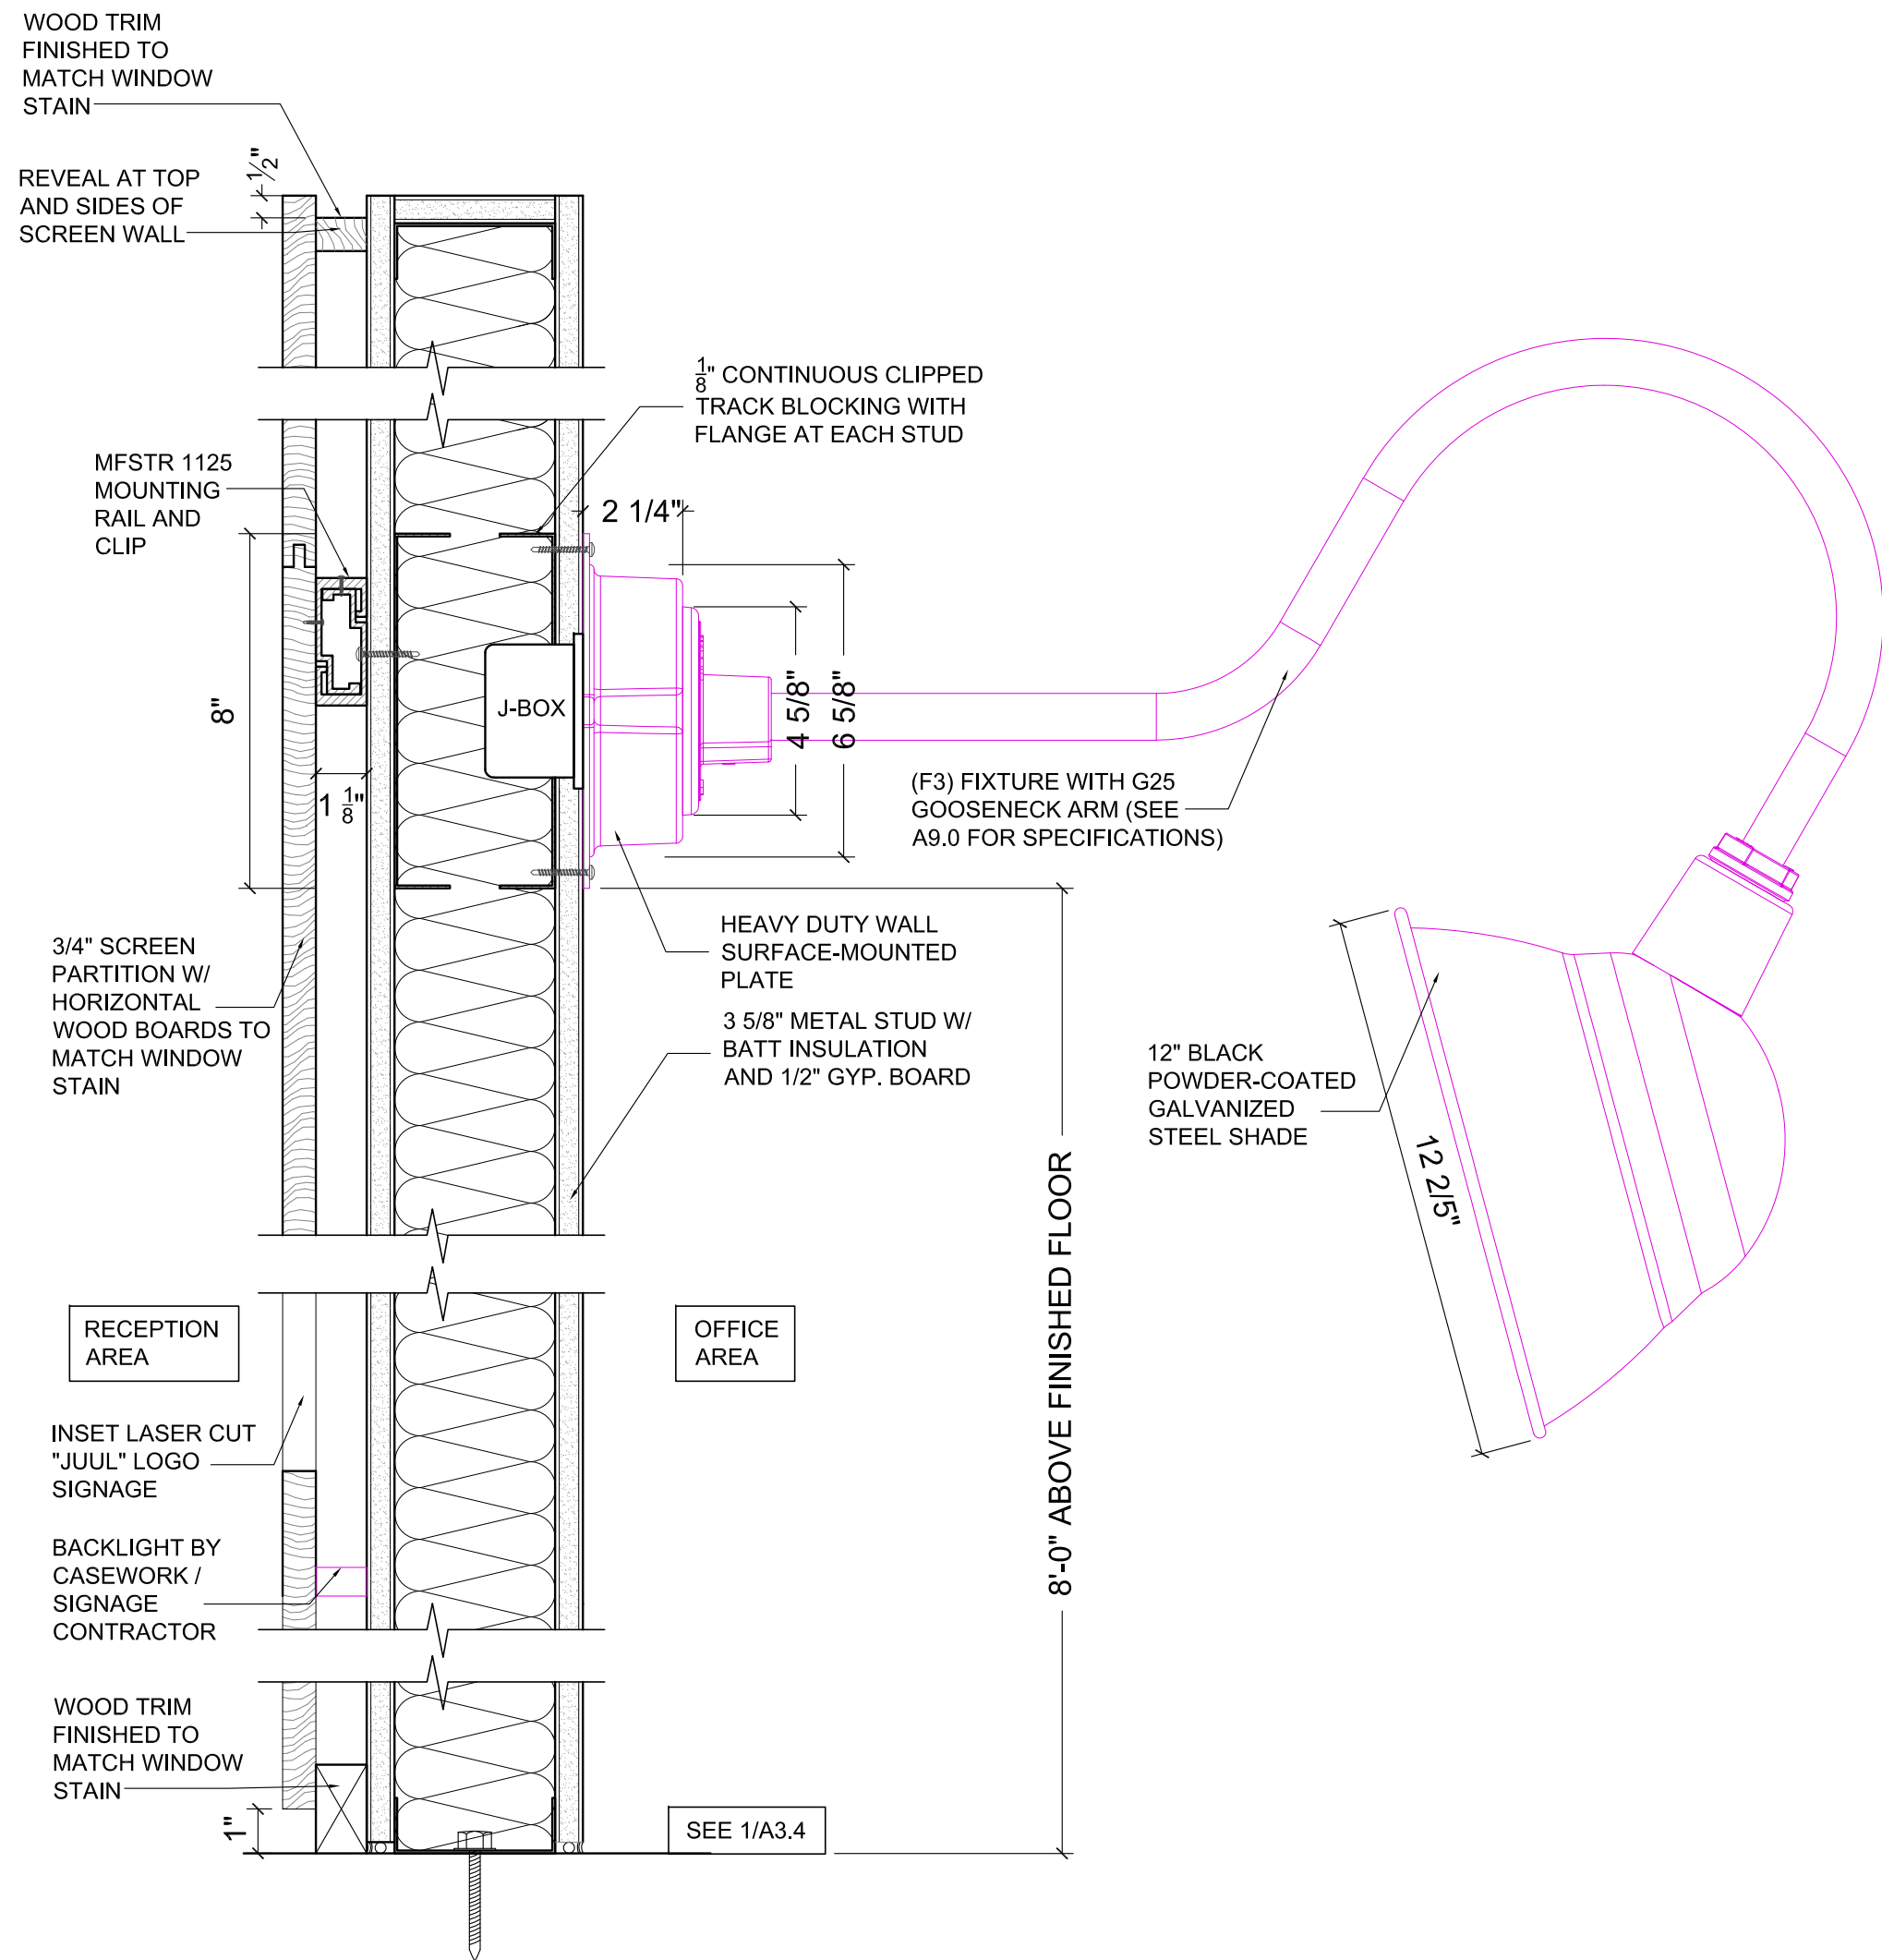


F23 GOOSENECK INDUSTRIAL SIGN LIGHTS BEHIND RECEPTION
3"= 1'-0" AT FULL SIZE (22'X34" PAPER SIZE)

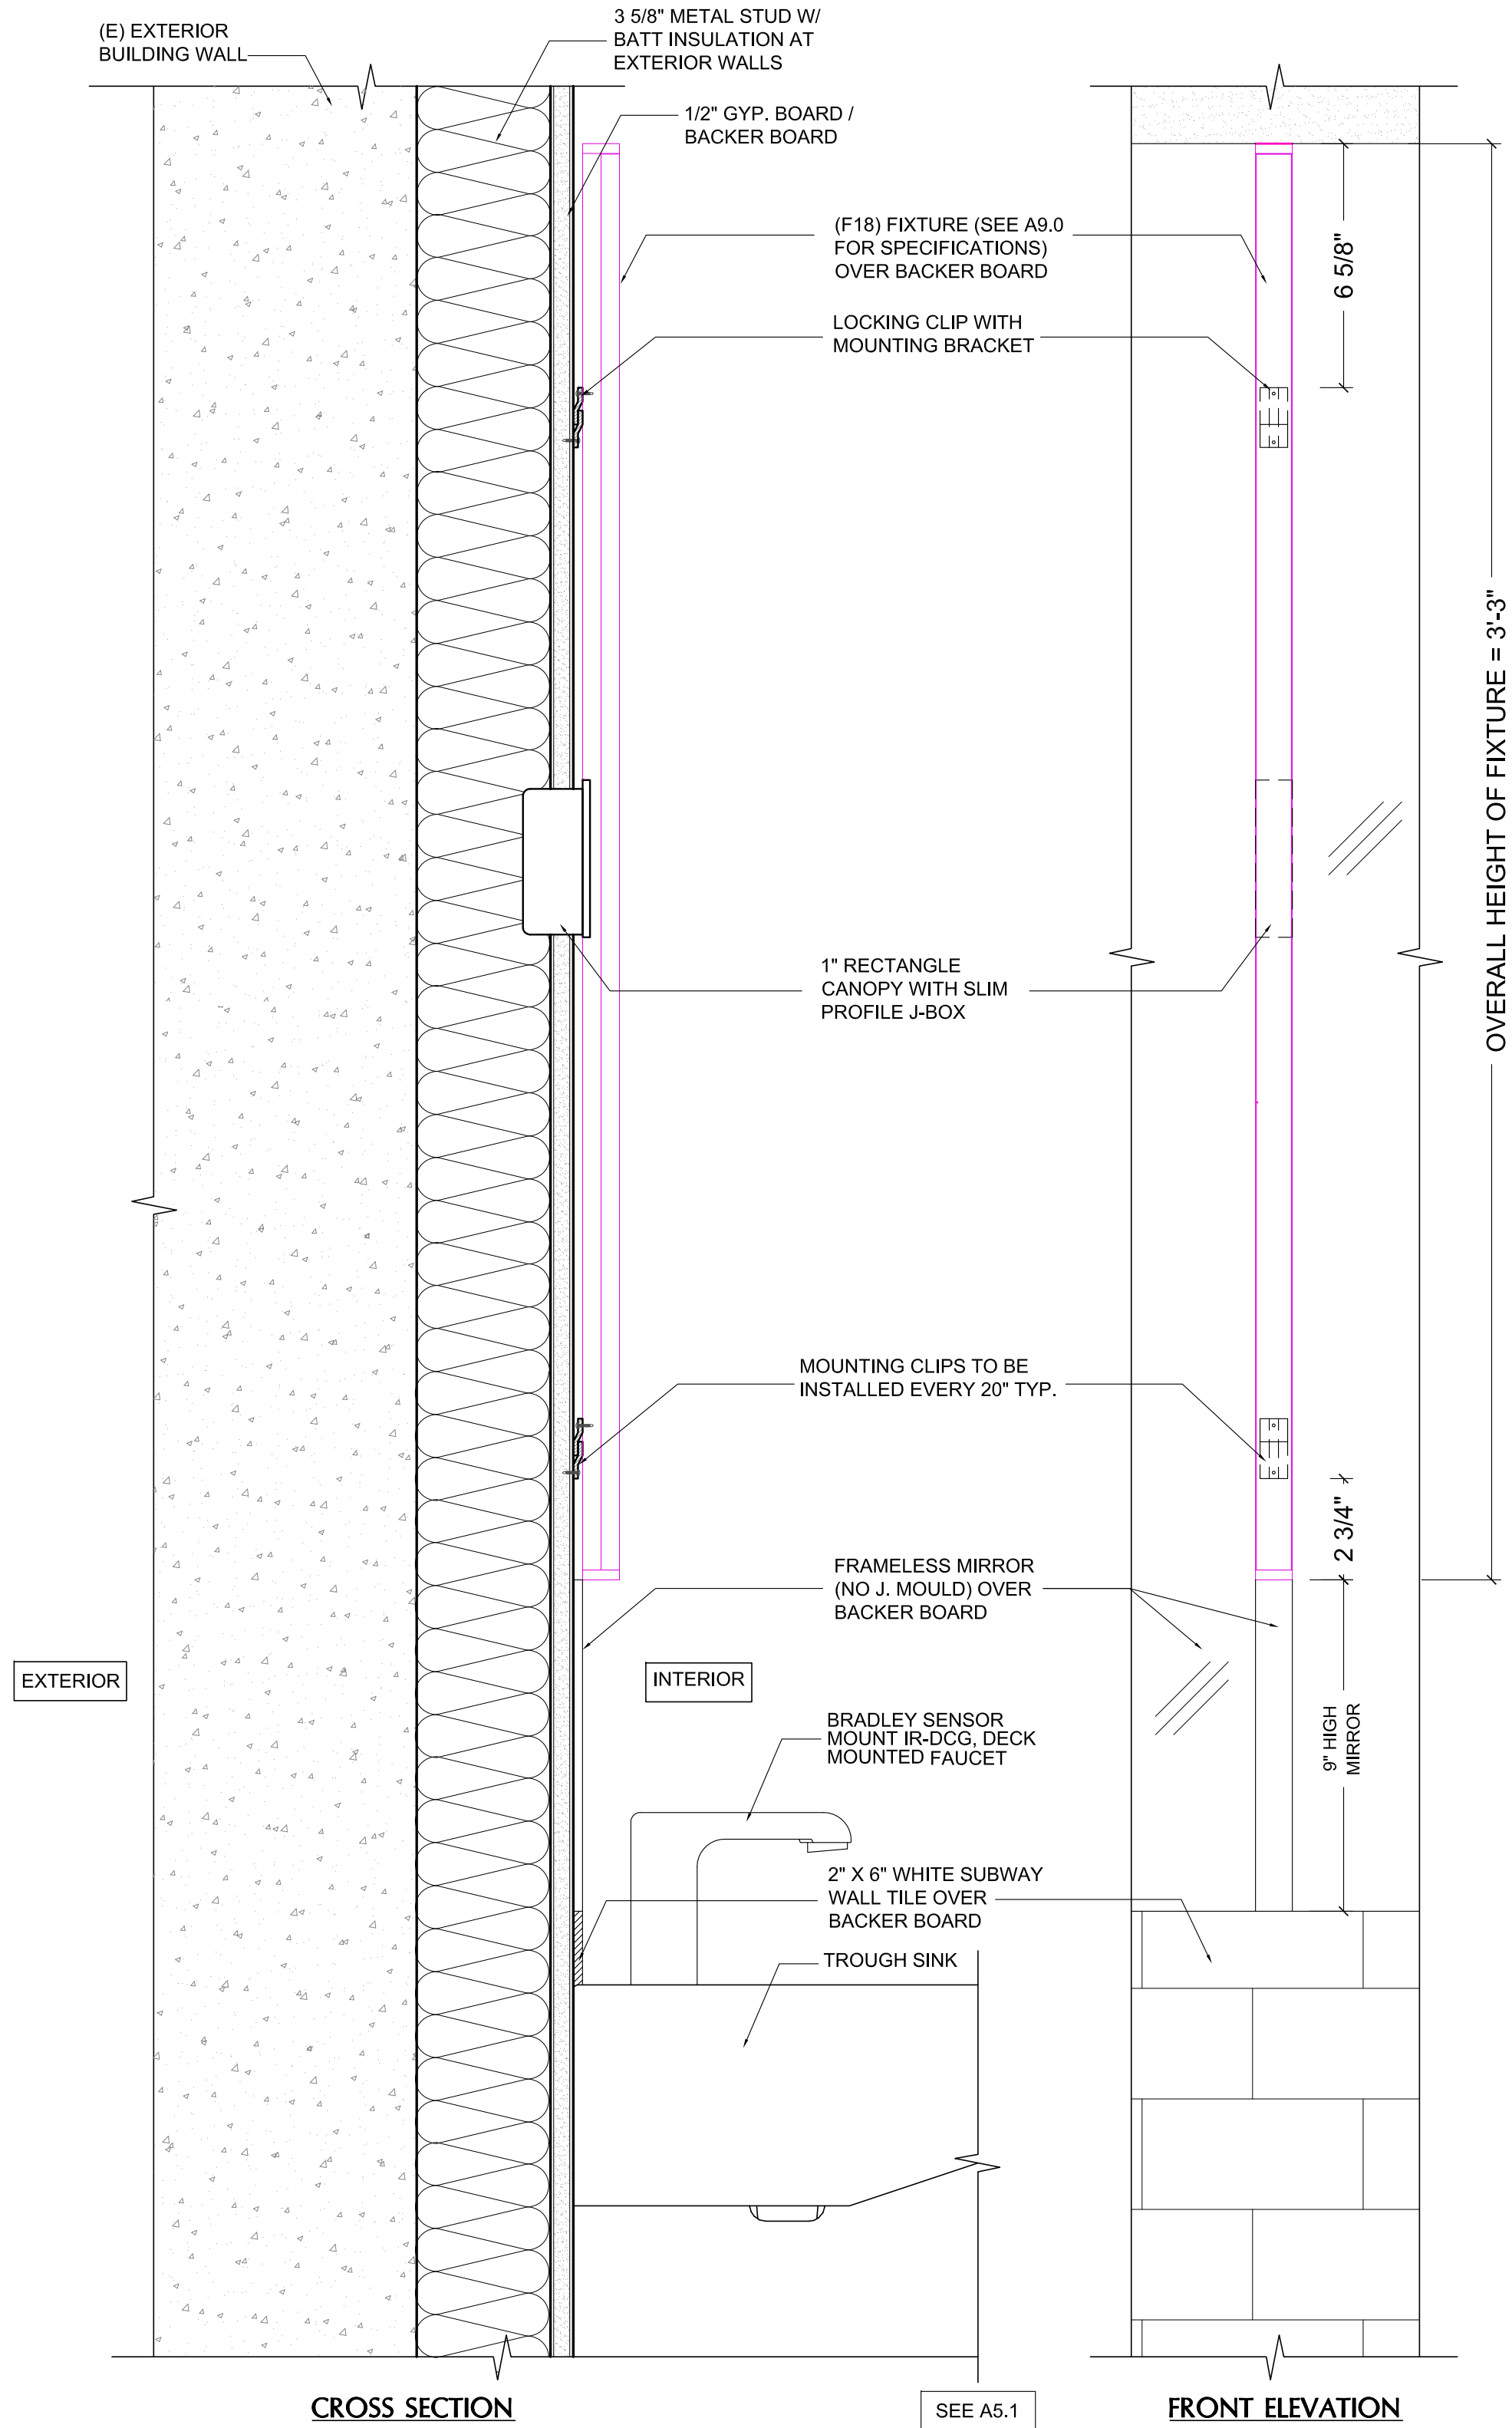

F18 VERTICAL SCONCE LIGHTING AT VANITY
3"= 1'-0" AT FULL SIZE (22'X34" PAPER SIZE)

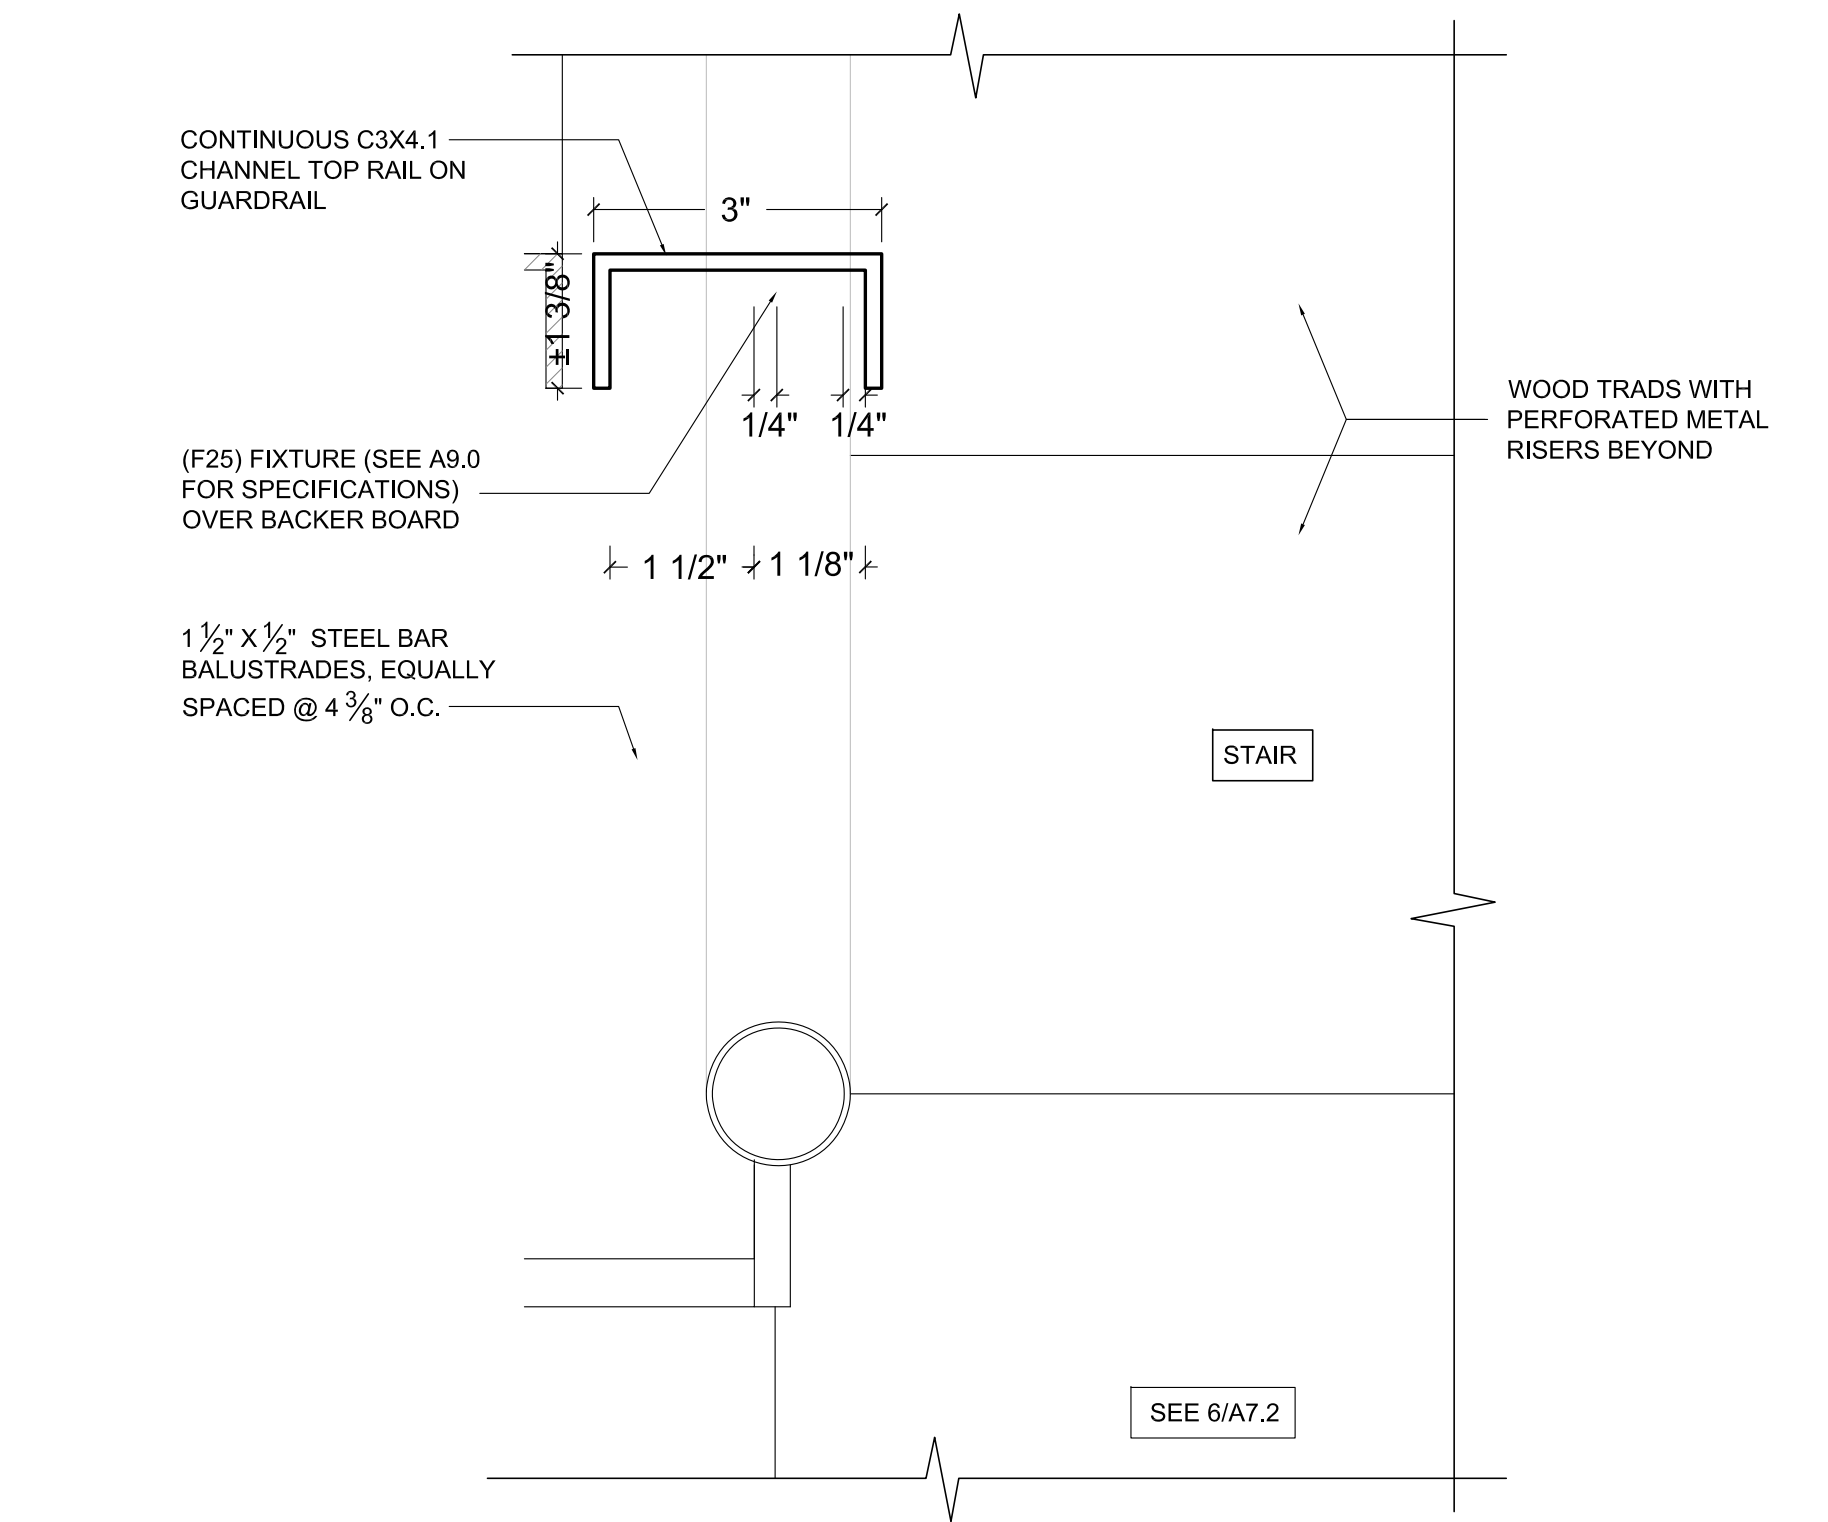

F25 LED TAPE LIGHT AT STAIRS
6"= 1'-0" AT FULL SIZE (22'X34" PAPER SIZE)

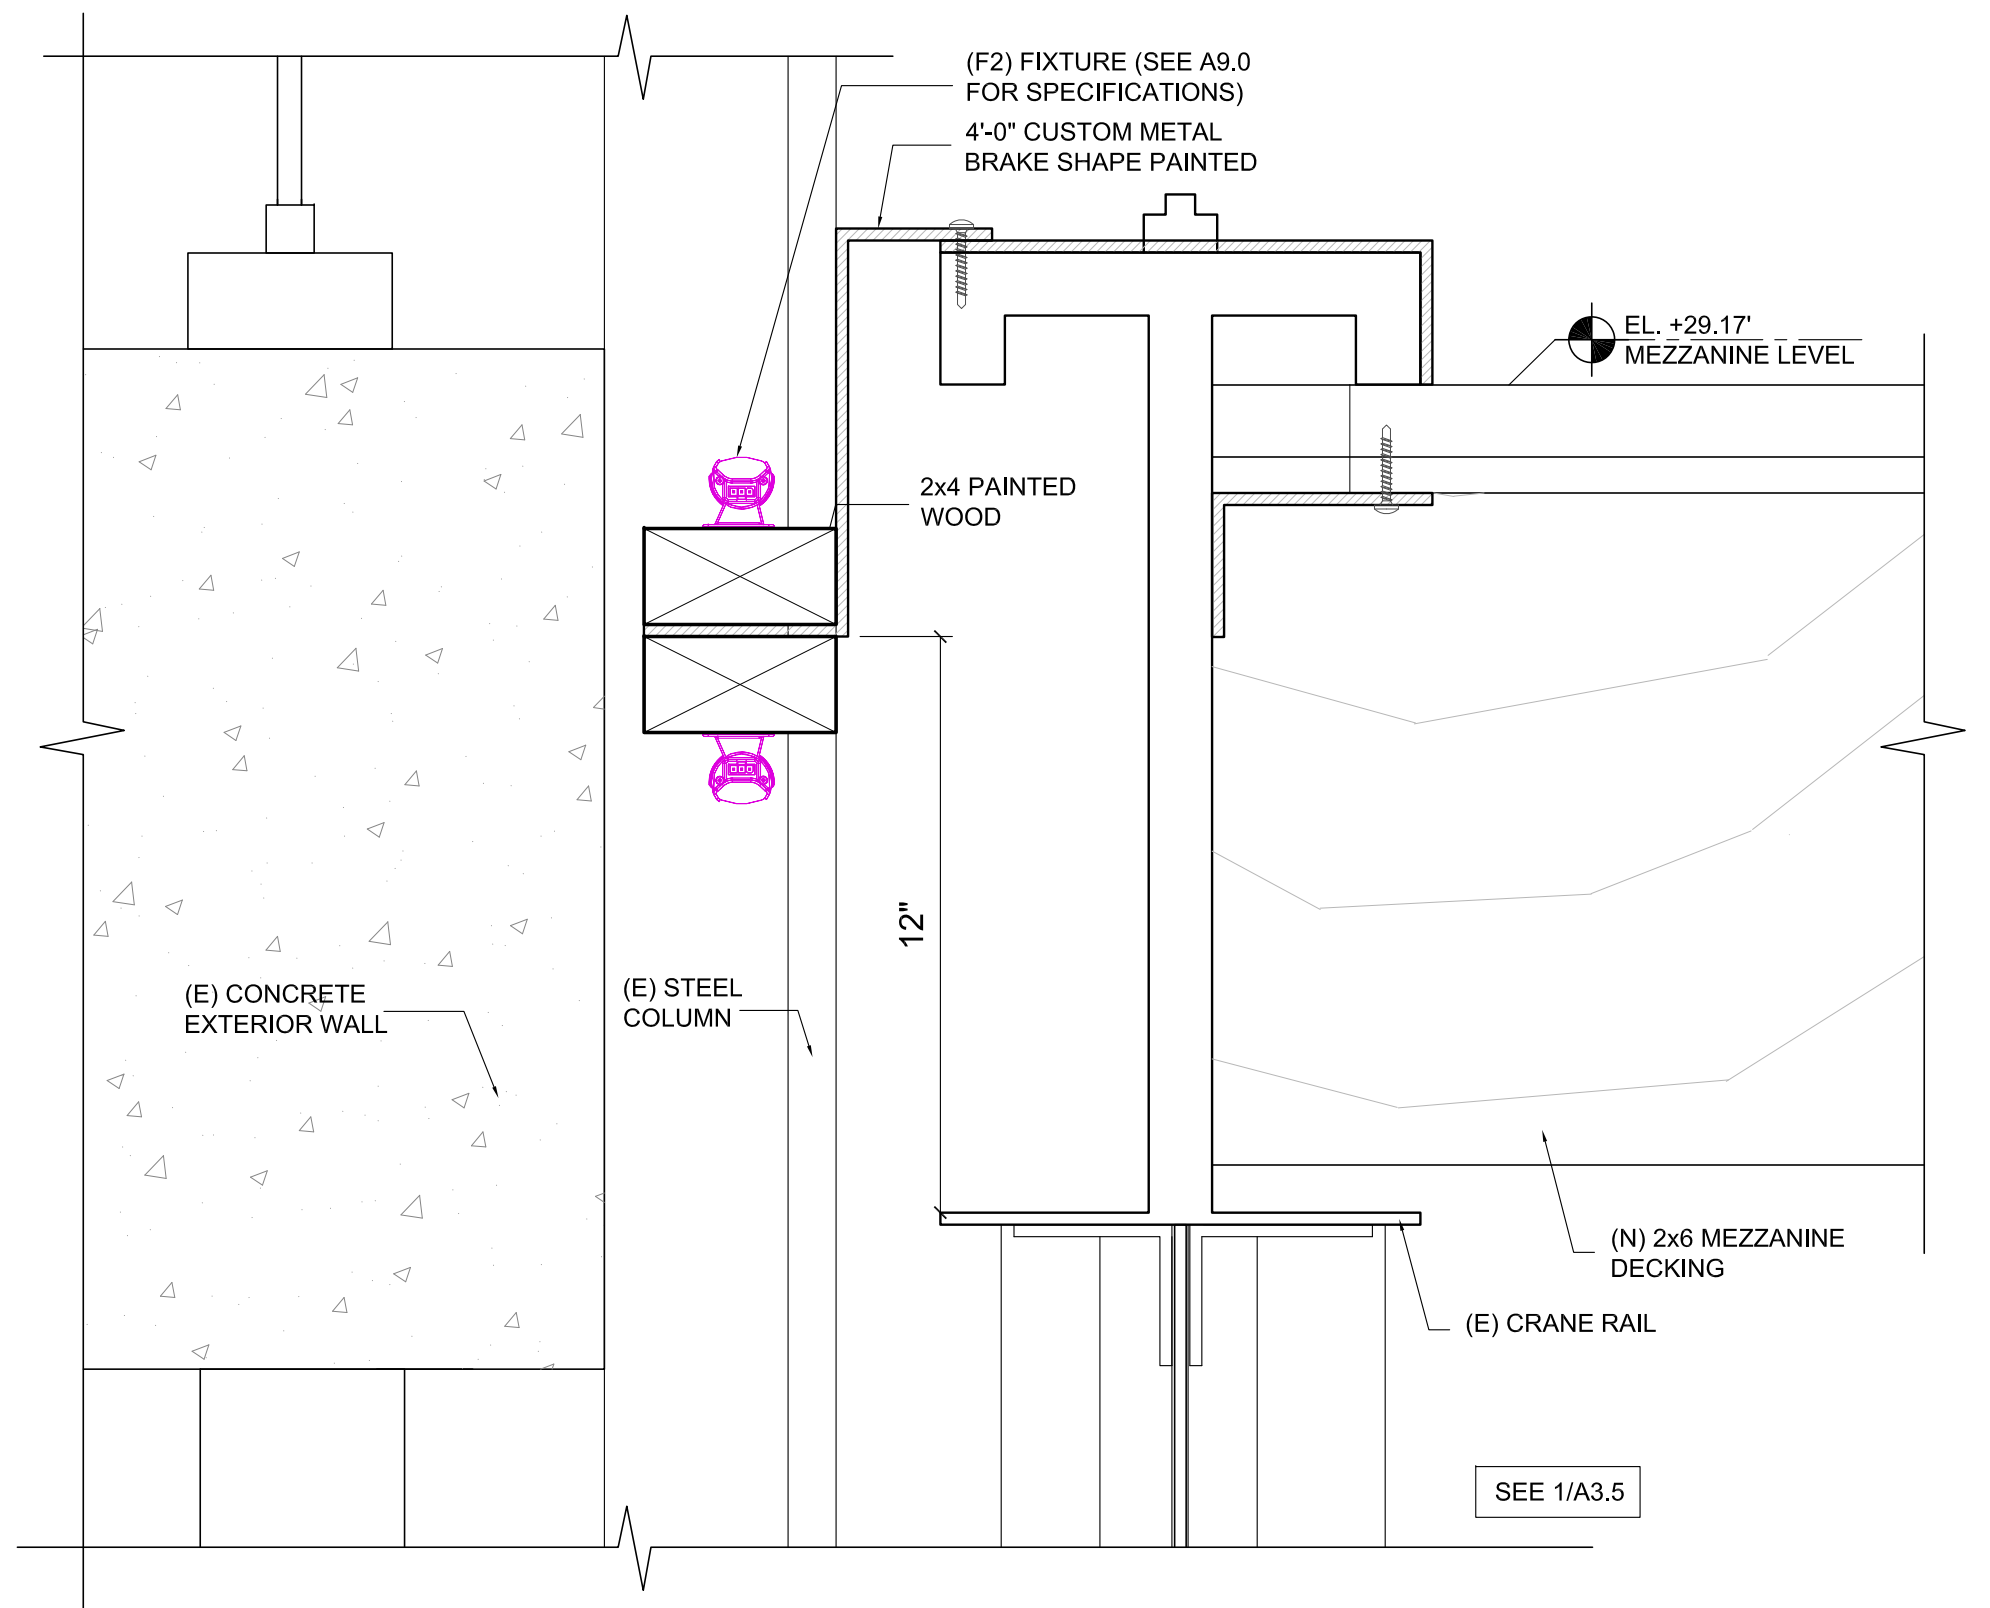

F2 LINEAR GRAZE DETAIL AT CRANE RAIL
3"= 1'-0" AT FULL SIZE (22'X34" PAPER SIZE)



SAN FRANCISCO PORT COMMISSION
PORT OF SAN FRANCISCO

Developer:
ORTON
DEVELOPMENT, INC.

1475 Powell Street, Suite 101
Emeryville CA 94608
tel: 510.734.7605

Architect:
**MARCY WONG
DONN LOGAN
ARCHITECTS**

800 Bancroft Way, Suite 200
Berkeley, CA 94710
tel: 510.843.0916

Consultant:

Stamp:

PIER 70 SAN FRANCISCO
HISTORIC 20TH STREET BUILDINGS

Revisions:

Sheet Name:
**BLDG. 102 LIGHTING FIXTURE
CROSS SECTION DETAILS UON**

Phase: For Final Approval
Date: 24 September, 2018
By: MW, KR, KS, SB, LZ, SW

Building
Number

102 A9.1

Sheet
Number

Developer:
ORTON
DEVELOPMENT, INC.

Architect:
MARCY WONG
DONN LOGAN
ARCHITECTS

Consultant:

Stamp:

Revisions:

Phase: For Final Approval
Date: 24 September, 2018
By: MW, KR, KS, SB, LZ, SW

102 A9.2

